

FIRST FLOOR PLAN

SCALE

1:25M



Republic of the Philippines
Cordillera Administrative Region
DEPARTMENT OF EDUCATION
SCHOOLS DIVISION OFFICE OF BAGUIO CITY
082 MILITARY CUT-OFF, BAGUIO CITY

PROJECT TITLE/LOCATION

PREPARED BY

RECOMMENDING APPROVAL

APPROVED BY

SHEET NO.

PROPOSED CONSTRUCTION OF
COMFORT ROOMS, HANDWASHING AND
COOKING AREA
COMFORT ROOM 1 & 2 (12SEATS WITH STORAGE)
LUCBAN ELEMENTARY SCHOOL, CAMOGAS, B.C.


JENNY R.D. POLIDO
ENGINEER III

APPROX. TONGAN
CHIEF SCOO

MARIE CAROLYN B. VERANO, CESO V
Schools Division Superintendent

10-24-20


1
18

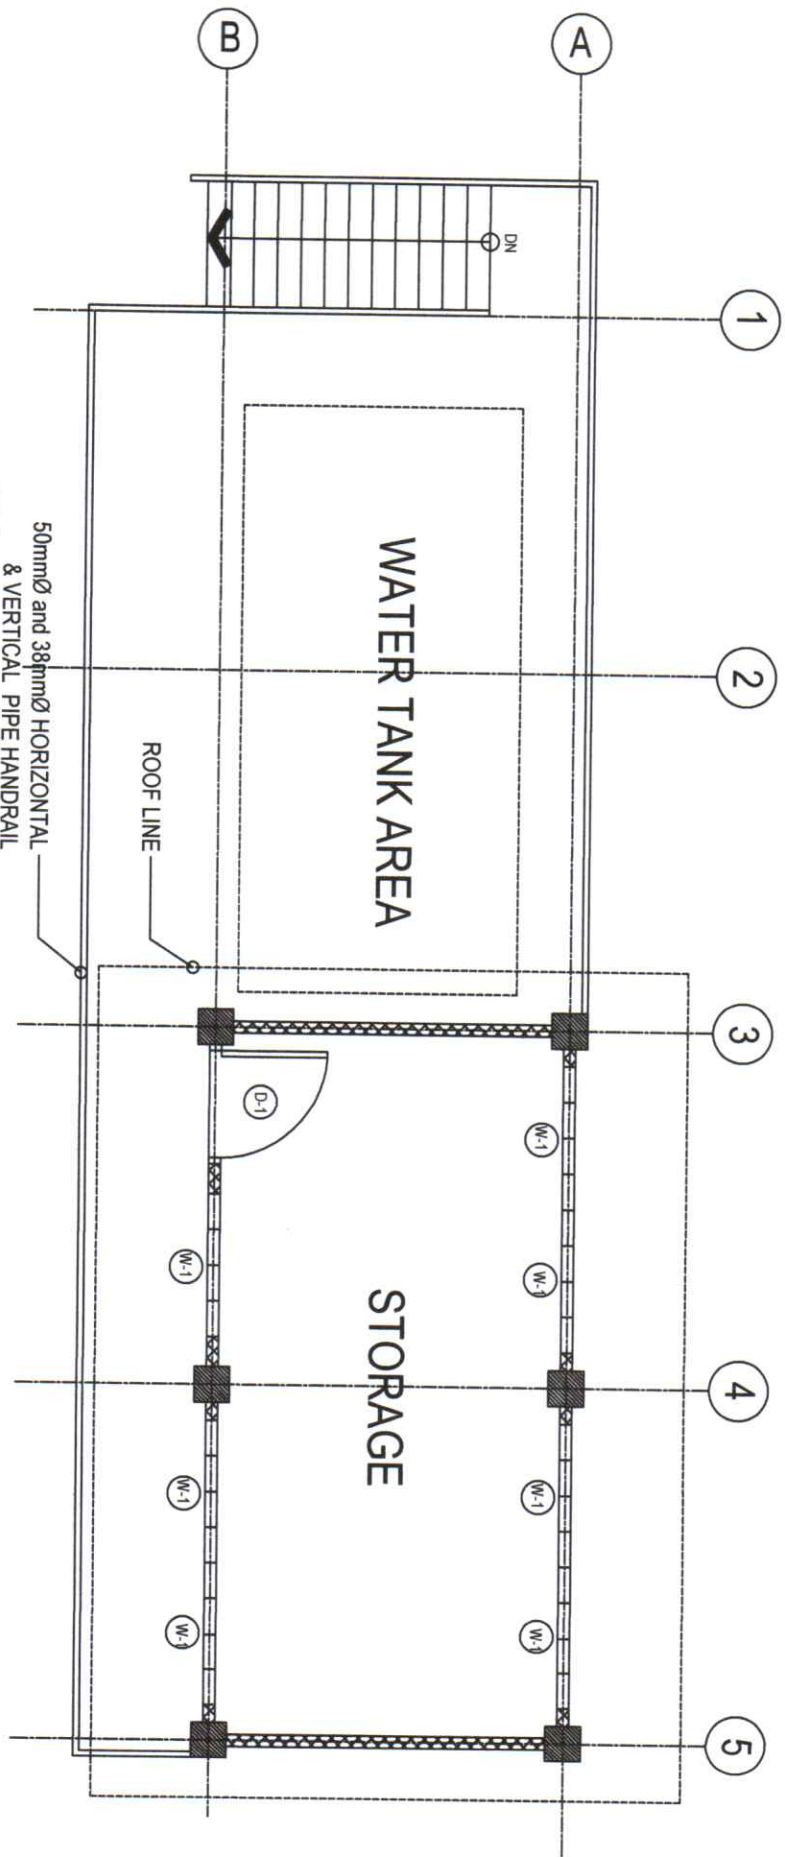

SECOND FLOOR PLAN

SCALE

1:25M

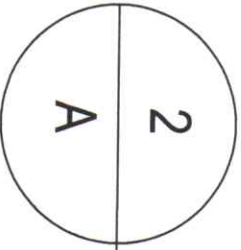

Republic of the Philippines
Cordillera Administrative Region
DEPARTMENT OF EDUCATION
SCHOOLS DIVISION OFFICE OF BAGUIO CITY
082 MILITARY CUT-OFF, BAGUIO CITY

PROJECT TITLE/LOCATION

PREPARED BY:

RECOMMENDING APPROVAL:

APPROVED BY:

SHEET NO.

 
PROPOSED CONSTRUCTION OF
COMFORT ROOMS, HANDWASHING AND
COOKING AREA
COMFORT ROOM 1 & 2 (12SEATS WITH STORAGE)
LUCBAN ELEMENTARY SCHOOL, CAMPOS, B.C.

JENNIFER A. POLDO
ENGINEER III

ARTHUR TIOGA
Chief SCOD

MARIE CAROLYN B. VERANO, CESO V
Schools Division Superintendent

2
18



Republic of the Philippines
Cordillera Administrative Region
DEPARTMENT OF EDUCATION
SCHOOLS DIVISION OFFICE OF BAGUIO CITY
082 MILITARY CUT-OFF, BAGUIO CITY

PROJECT TITLE/LOCATION

PREPARED BY

RECOMMENDING APPROVAL

APPROVED BY:

SHEET NO.

PROPOSED CONSTRUCTION OF
COMFORT ROOMS, HANDWASHING AND

JENNIFER B. POLDO

COMFORT ROOM 1 & 2 (12SEATS WITH STORAGE)


ARTHUR TIONGAN

Chief-SCOD

MARIE CAROLYN B. VERANO, CESO V

Schools Division Superintendent


10-29-80
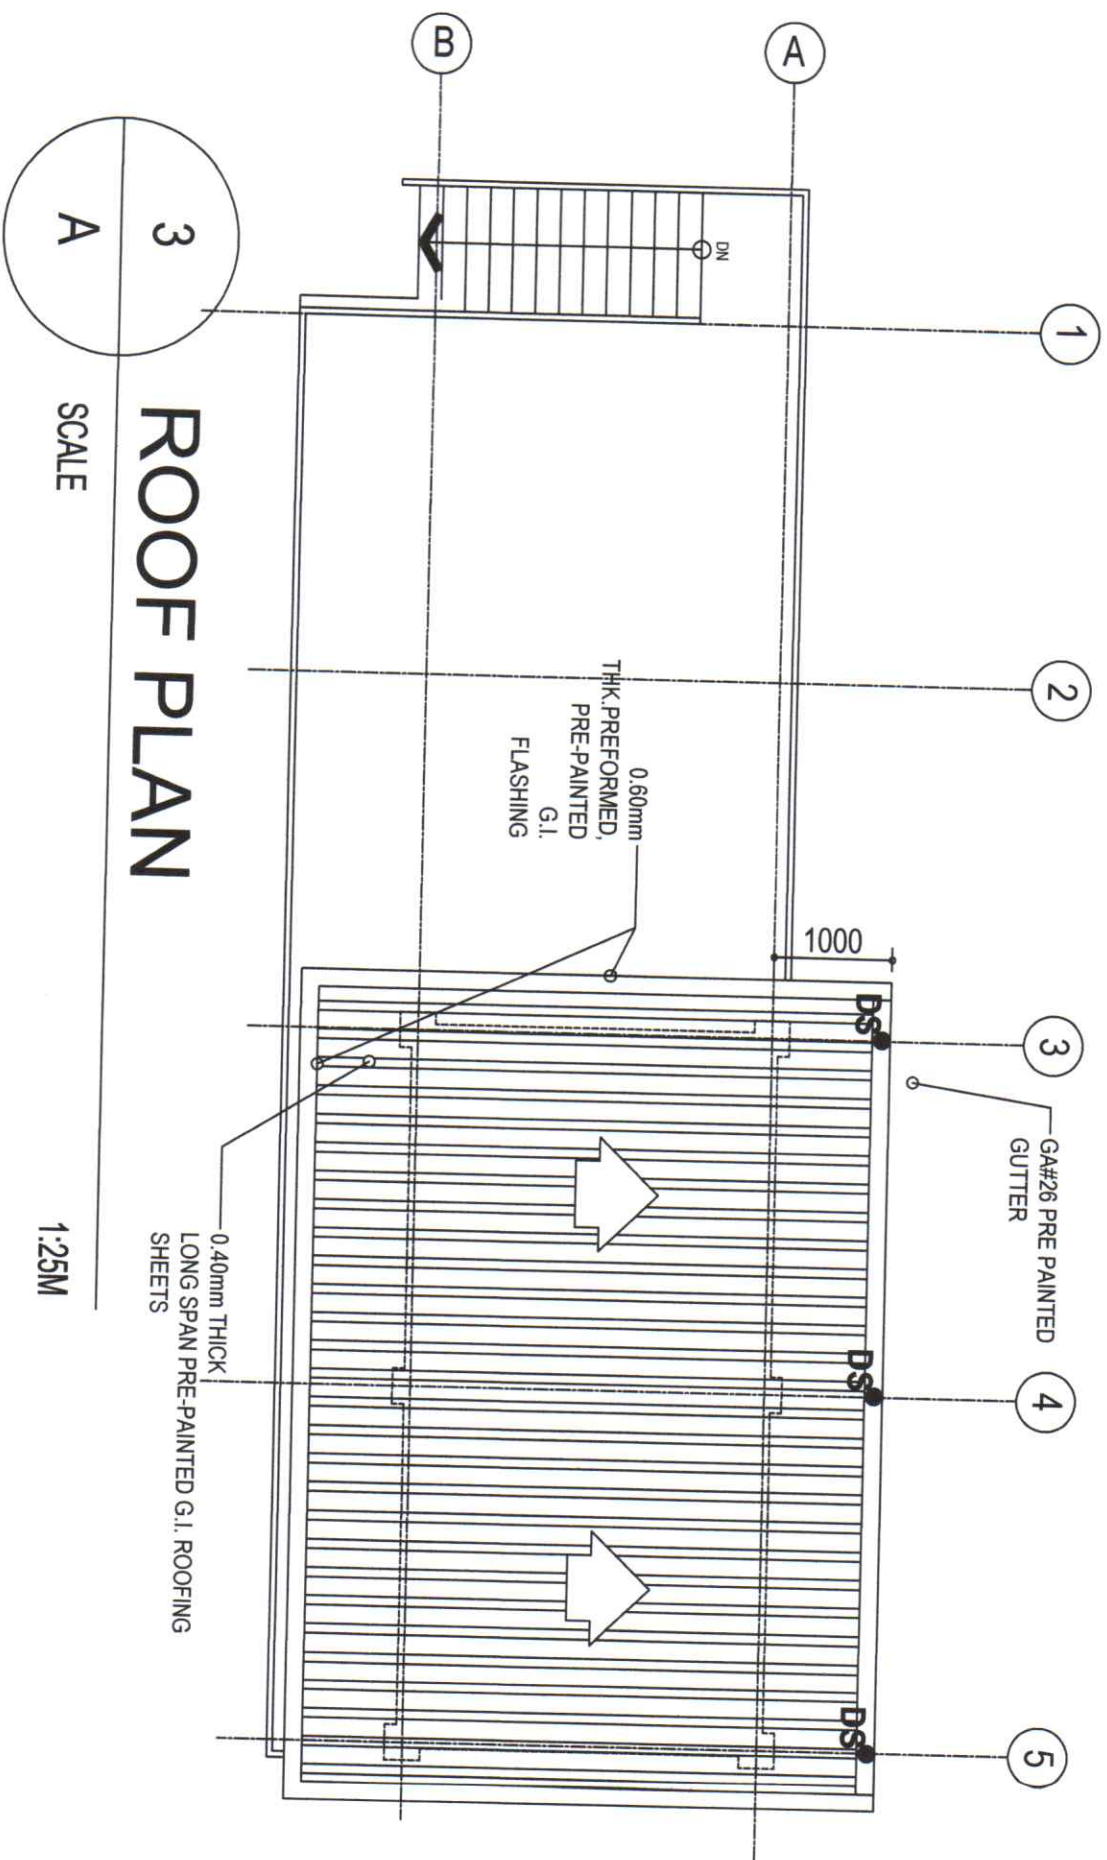
$$\frac{3}{18}$$


ROOF PLAN

SCALE

1.25M

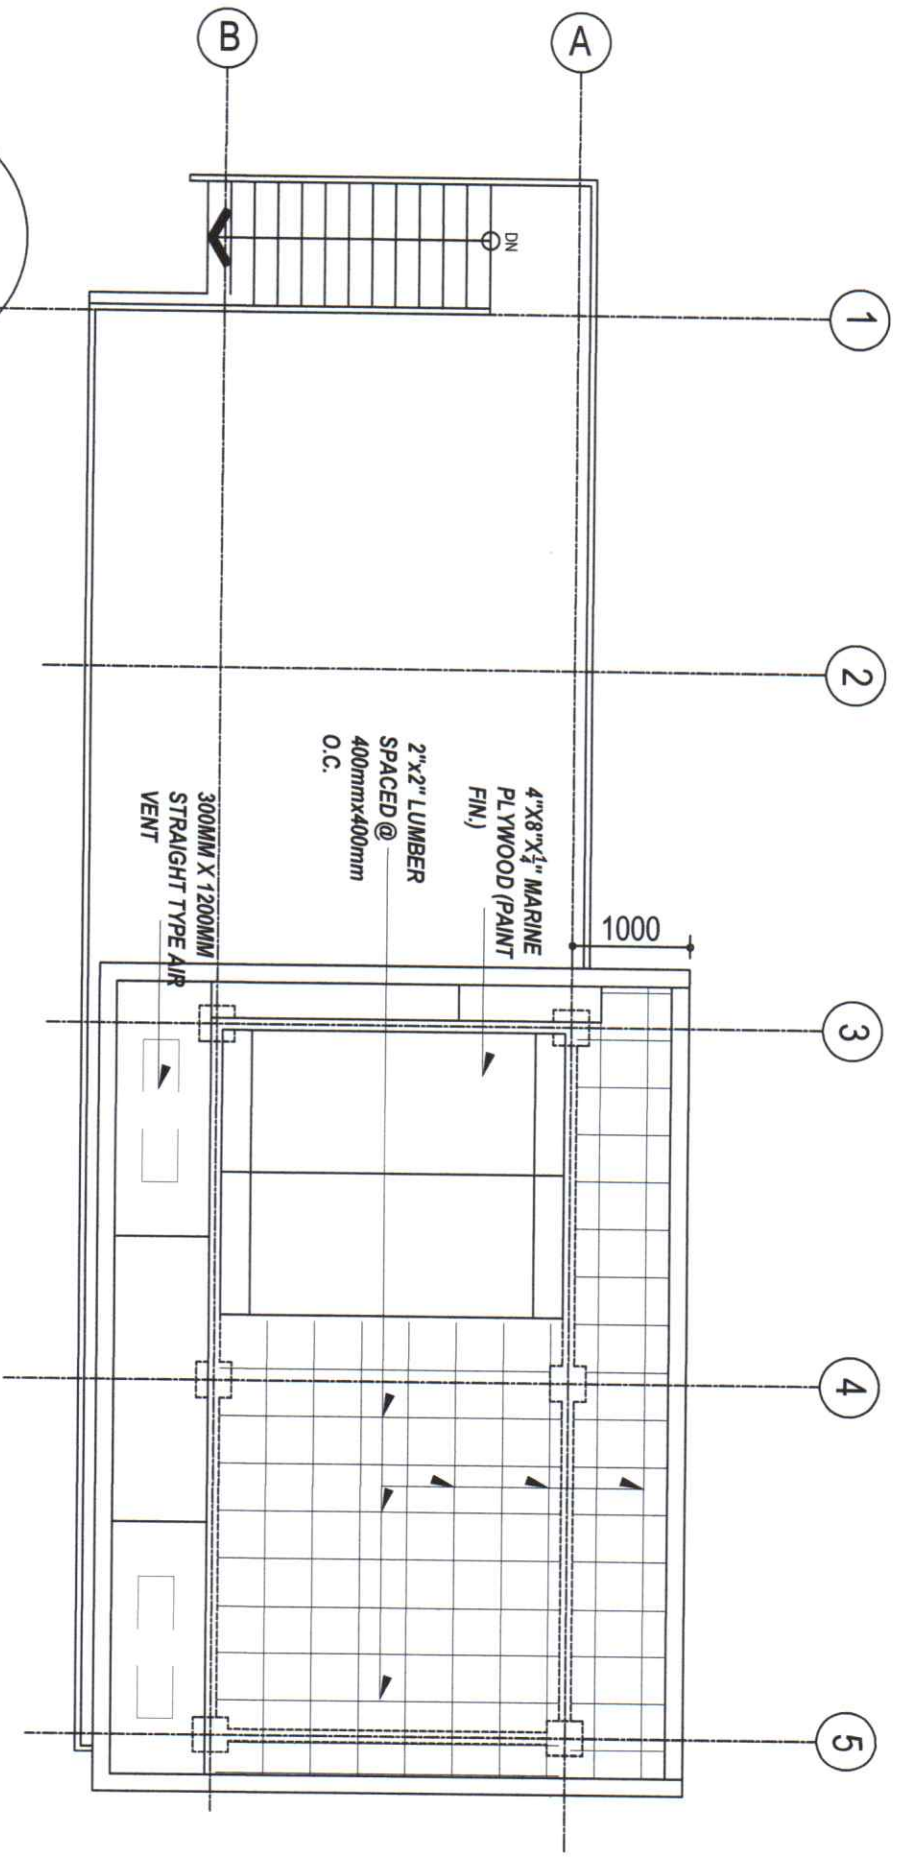

4
A

2ND FLR CEILING PLAN

SCALE 1:25M



Republic of the Philippines
Cordillera Administrative Region
DEPARTMENT OF EDUCATION
SCHOOLS DIVISION OFFICE OF BAGUIO CITY
092 MILITARY CUT-OFF, BAGUIO CITY

PROJECT TITLE/LOCATION

PREPARED BY:

RECOMMENDING APPROVAL:

APPROVED BY:

SHEET NO.


PROPOSED CONSTRUCTION OF
COMFORT ROOMS, HANDWASHING AND
COOKING AREA
COMFORT ROOM 1 & 2 (2SEATS WITH STORAGE)
LUCBAN ELEMENTARY SCHOOL, CAMPOS, B.C.

JENNIFER A. POLDO
ENGINEER III

ARMAUD TIOGIAN
Chief SCOD

MARIE CAROLYN B. VERANO, CESO V
Schools Division Superintendent
10-29-20

4
18

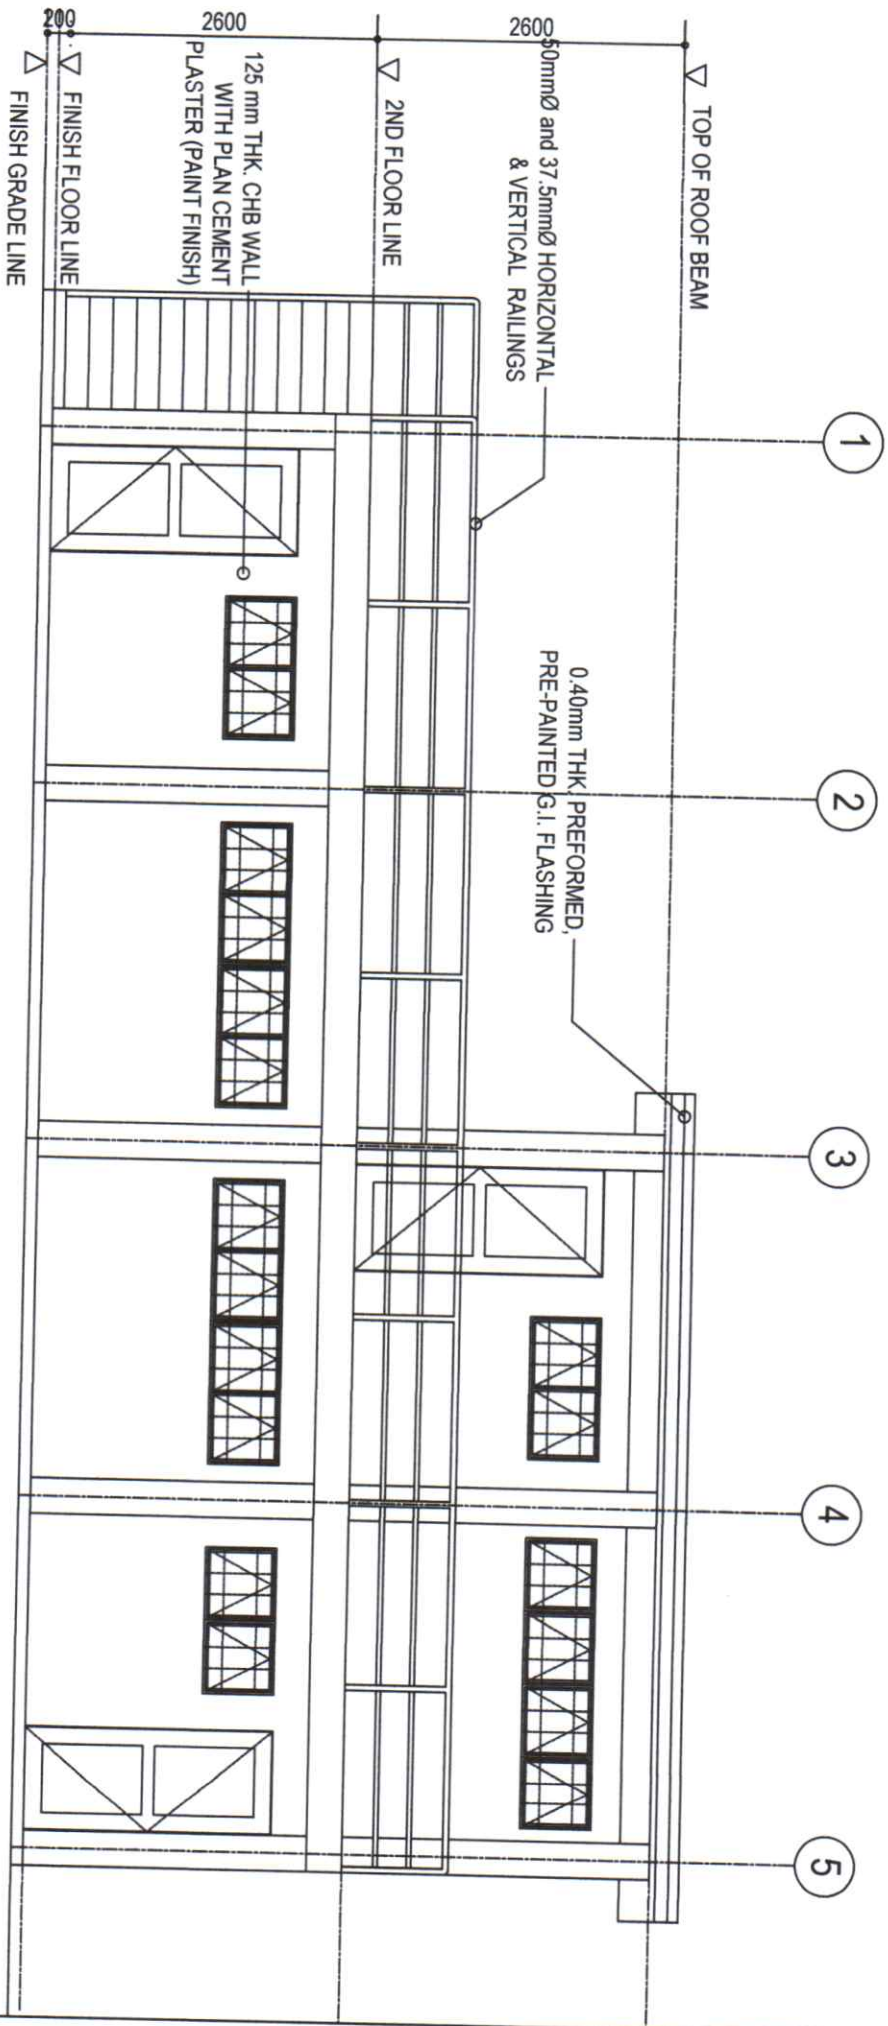

5
A

FRONT ELEVATION

SCALE

1:25M



Republic of the Philippines
Cordillera Administrative Region
DEPARTMENT OF EDUCATION
SCHOOLS DIVISION OFFICE OF BAGUIO CITY
082 MILITARY CUT-OFF, BAGUIO CITY

PROJECT TITLE/LOCATION

PREPARED BY

RECOMMENDING APPROVAL

APPROVED BY

SHEET NO.



PROPOSED CONSTRUCTION OF
COMFORT ROOMS, HANDWASHING AND
COOKING AREA
COMFORT ROOM 1 & 2 (12SEATS WITH STORAGE)
LUCBAN ELEMENTARY SCHOOL, CAMUS, B.C.

JENNIFER D. POBRO
ENGINEER III

APPROVED BY
CHIEF-SCOD

MARIE CAROLYN B. VERANO, CESO V
Schools Division Superintendent

5
18

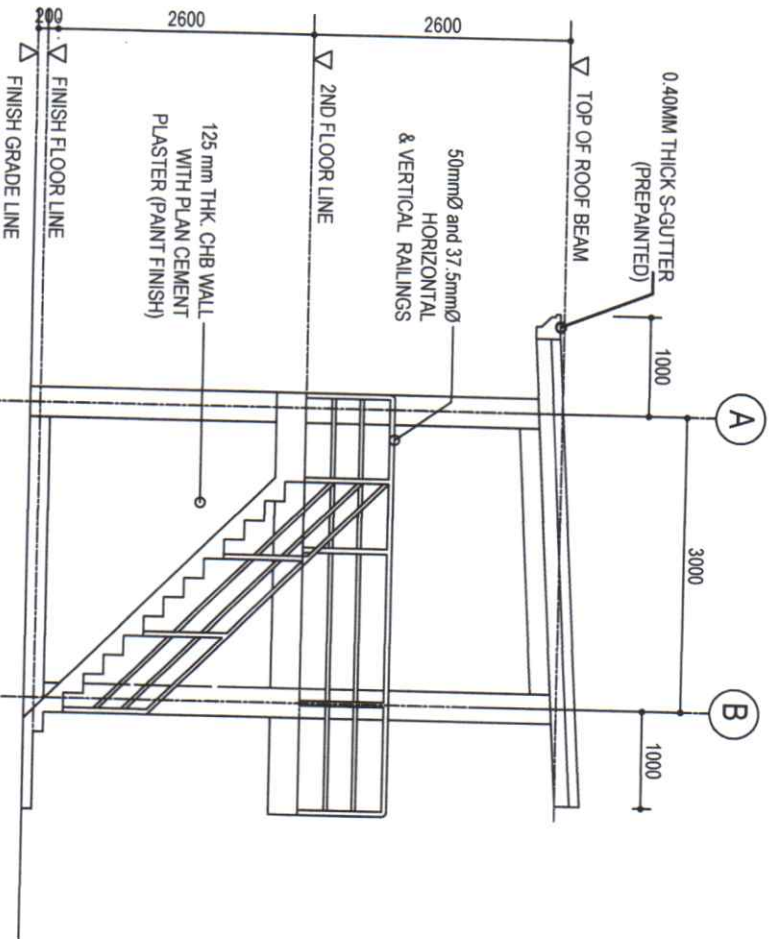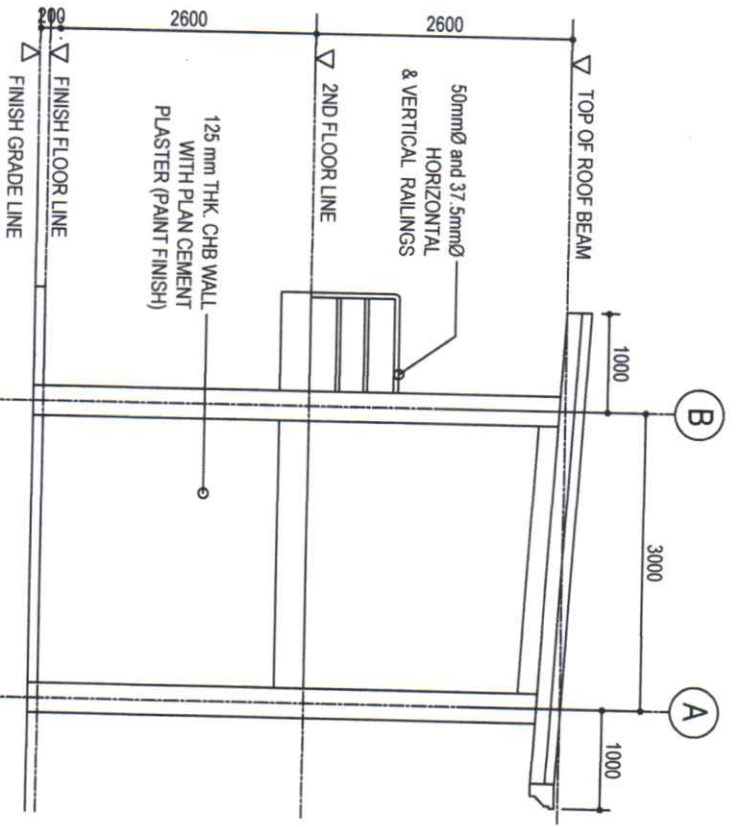

RIGHT SIDE ELEVATION

A

SCALE

1:30M

LEFT SIDE ELEVATION

A

SCALE

1:30M



Republic of the Philippines
Cavite Administrative Region
DEPARTMENT OF EDUCATION
SCHOOLS DIVISION OFFICE OF BAGUIO CITY
082 MILITARY CUT-OFF, BAGUIO CITY

PROJECT TITLE/LOCATION

PREPARED BY

RECOMMENDING APPROVAL

APPROVED BY

SHEET NO.

PROPOSED CONSTRUCTION OF
COMFORT ROOMS, HANDWASHING AND
COOKING AREA


COMFORT ROOM 1 & 2 (12 SEATS WITH STORAGE)
LUCBAN ELEMENTARY SCHOOL, CAMRUS, B.C.

JENIVER R. ROLDO
ENGINEER III

ARTHUR TONGAN
CHIEF SCOO

MARIE CAROLYN B. VERANO, CESO V
Schools Division Superintendent

6
18

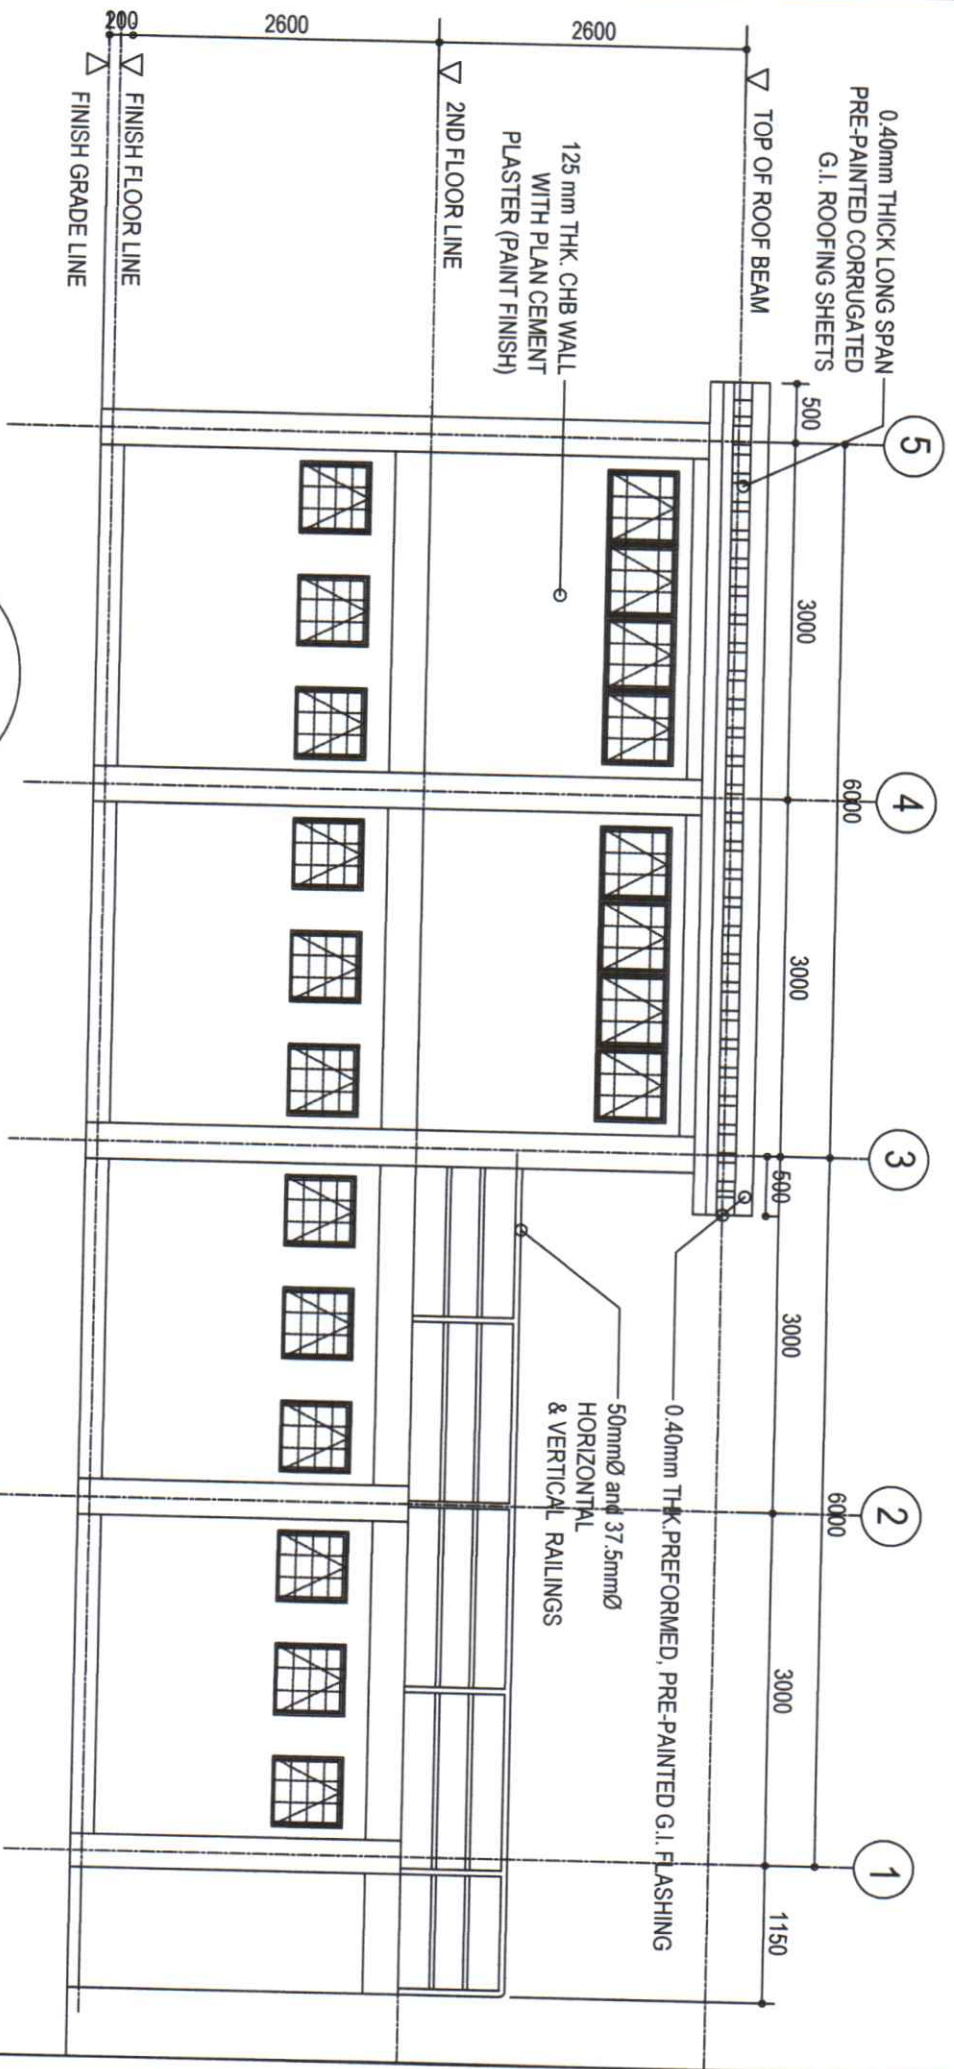

REAR ELEVATION

SCALE

1:25M



Republic of the Philippines
Cordillera Administrative Region
DEPARTMENT OF EDUCATION
SCHOOLS DIVISION OFFICE OF BAGUIO CITY
082 MILITARY CUT-OFF, BAGUIO CITY

PROJECT TITLE/LOCATION
PROPOSED CONSTRUCTION OF
COMFORT ROOMS, HANDWASHING AND
COOKING AREA
COMFORT ROOM 1 & 2 (12SEATS WITH STORAGE)
LUCBAN ELEMENTARY SCHOOL, CAMAS, B.C.


PREPARED BY
JENNIFER B. ROLDO
ENGINEER III

RECOMMENDING APPROVAL
ARTHUR TONGAN
CHIEF SCOD

APPROVED BY
MARIE CAROLYN B. VERANO, CESO V
Schools Division Superintendent

SHEET NO.

7
18

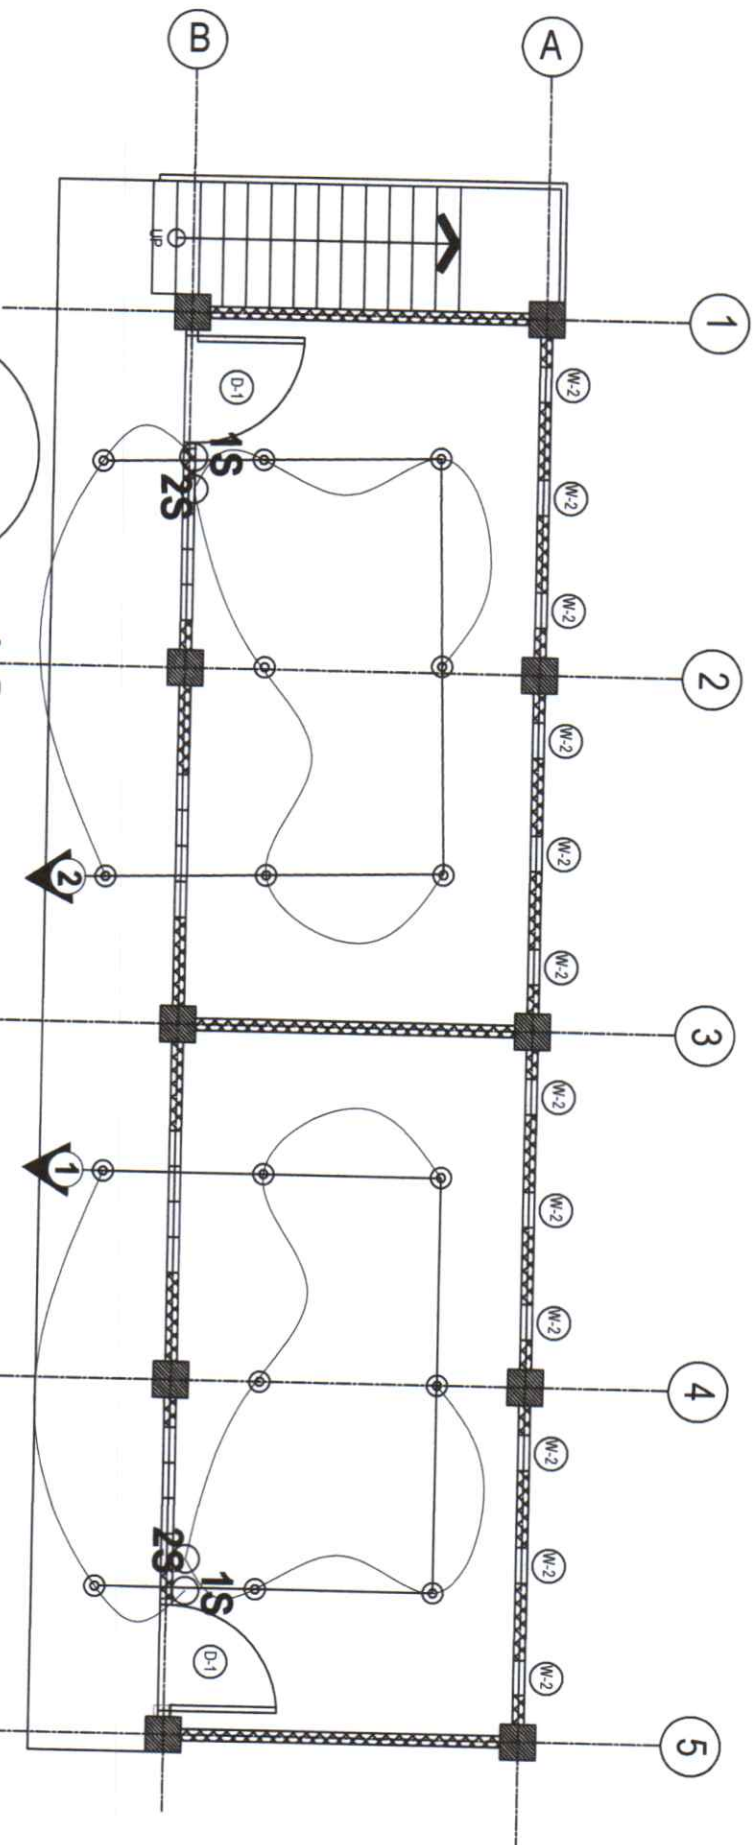


1
E

1ST FLR LIGHTING LAY-OUT

SCALE
1:60M

PROJECT TITLE/LOCATION	PROPOSED CONSTRUCTION OF COMFORT ROOMS, HANDWASHING AND COOKING AREA COMFORT ROOM 1 & 2 (22SEATS WITH STORAGE)	PREPARED BY	RECOMMENDING APPROVAL	APPROVED BY	SHEET NO.
	LUBAN ELEMENTARY SCHOOL, CAMAS, B.C.	JENNIFER D. AQUINO ENGINEER III	ARTYOR SONGAN CHIEF SCOD	MARIE CAROLYN B. VERANO, CESO V Schools Division Superintendent	8 18

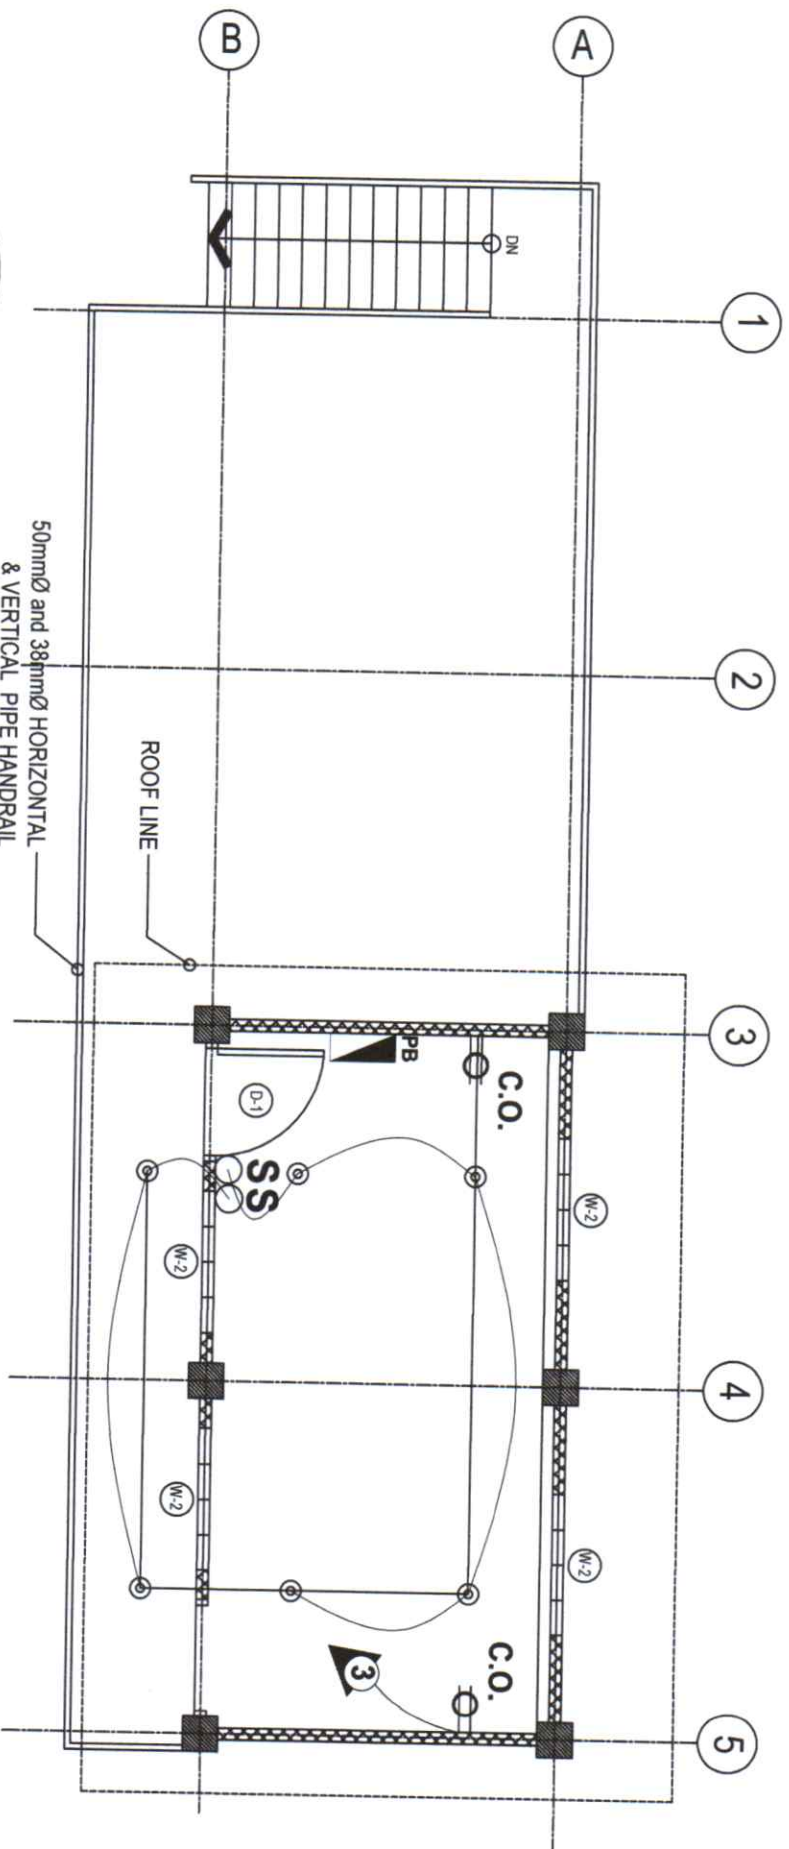

2ND FLR LIGHTING/POWER LAY-OUT

E SCALE

1:60M



Republic of the Philippines
Cordillera Administrative Region
DEPARTMENT OF EDUCATION
SCHOOLS DIVISION OFFICE OF BAGUIO CITY
082 MILITARY CUT-OFF, BAGUIO CITY

PROJECT TITLE/LOCATION

PREPARED BY

RECOMMENDING APPROVAL

APPROVED BY

SHEET NO.

PROPOSED CONSTRUCTION OF
COMFORT ROOMS, HANDWASHING AND
COOKING AREA

COMFORT ROOM 1 & 2 (2 SEATS WITH STORAGE)
LUCBAN ELEMENTARY SCHOOL, CAMPOS, B.C.



JENNIFER ROLDAN
ENGINEER III

ARTHUR TINGGAN
Chief SCOD

MARIE CAROLYN B. VERANO, CESO V
Schools Division Superintendent
10-28-26

9


18

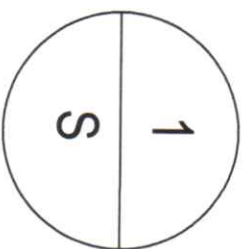
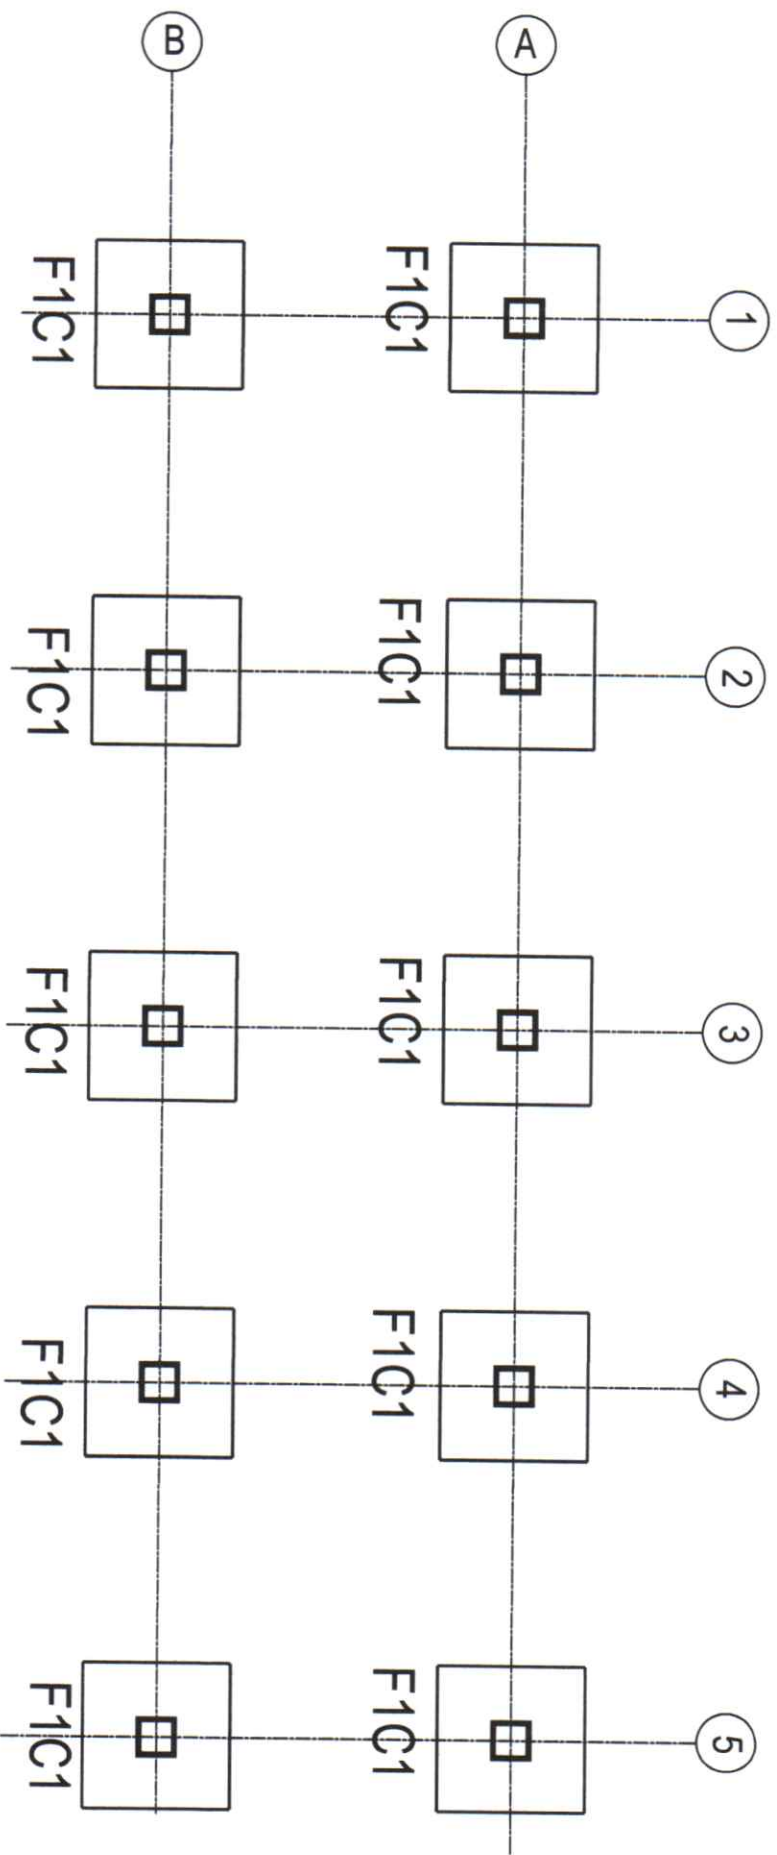


FOUNDATION PLAN

SCALE


1:25M


 Republic of the Philippines Cordillera Administrative Region DEPARTMENT OF EDUCATION SCHOOLS DIVISION OFFICE OF BAGUIO CITY 0822 MILITARY CUT-OFF, BAGUIO CITY		PROJECT TITLE/LOCATION: PROPOSED CONSTRUCTION OF COMFORT ROOMS, HANDWASHING AND COOKING AREA COMFORT ROOM 1 & 2 (25SEATS WITH STORAGE) LUOGAN ELEMENTARY SCHOOL, CAMPOS, B.C.		PREPARED BY: JENNIFER D. POLIDO ENGINEER III		RECOMMENDING APPROVAL: APRIL D. JONSON CHIEF SCOD		APPROVED BY: MARIE CAROLYN B. VERANO, CESO V Schools Division Superintendent		SHEET NO. 10 18	
---	--	--	--	--	--	---	--	--	--	---------------------------	--

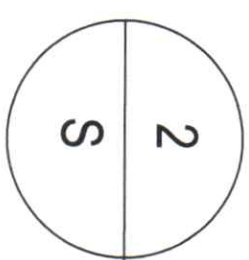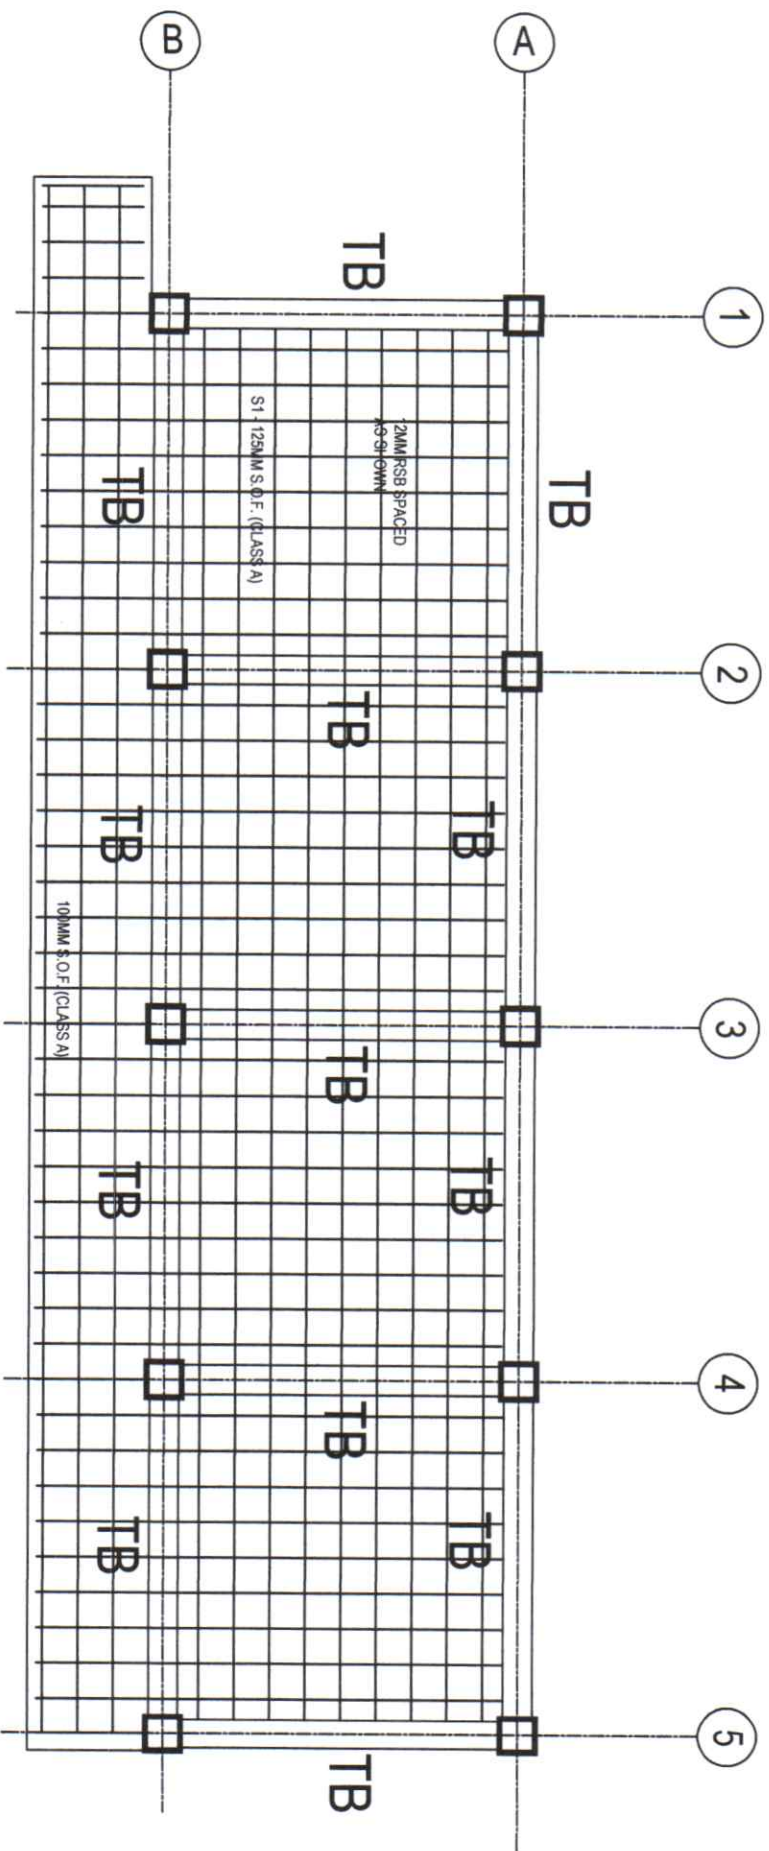


1ST FLR FRAMING PLAN


SCALE
1:25M

 Republic of the Philippines Cordillera Administrative Region DEPARTMENT OF EDUCATION SCHOOLS DIVISION OFFICE OF BAGUIO CITY 082 MILITARY CUT-OFF, BAGUIO CITY		PROJECT TITLE/LOCATION PROPOSED CONSTRUCTION OF COMFORT ROOMS, HANDWASHING AND COOKING AREA COMFORT ROOM 1 & 2 (12SEATS WITH STORAGE) LUCBAN ELEMENTARY SCHOOL, CAMAS, B.C.		PREPARED BY JENNIFER A. ROLDO ENGINEER III		RECOMMENDING APPROVAL ARTHUR LINGAN Chair-SCOD		APPROVED BY MARIE CAROLYN B. VERANO, CESO V Schools Division Superintendent KC-84-10		SHEET NO. 11 18	
--	--	--	--	--	--	--	--	--	--	-----------------------	--

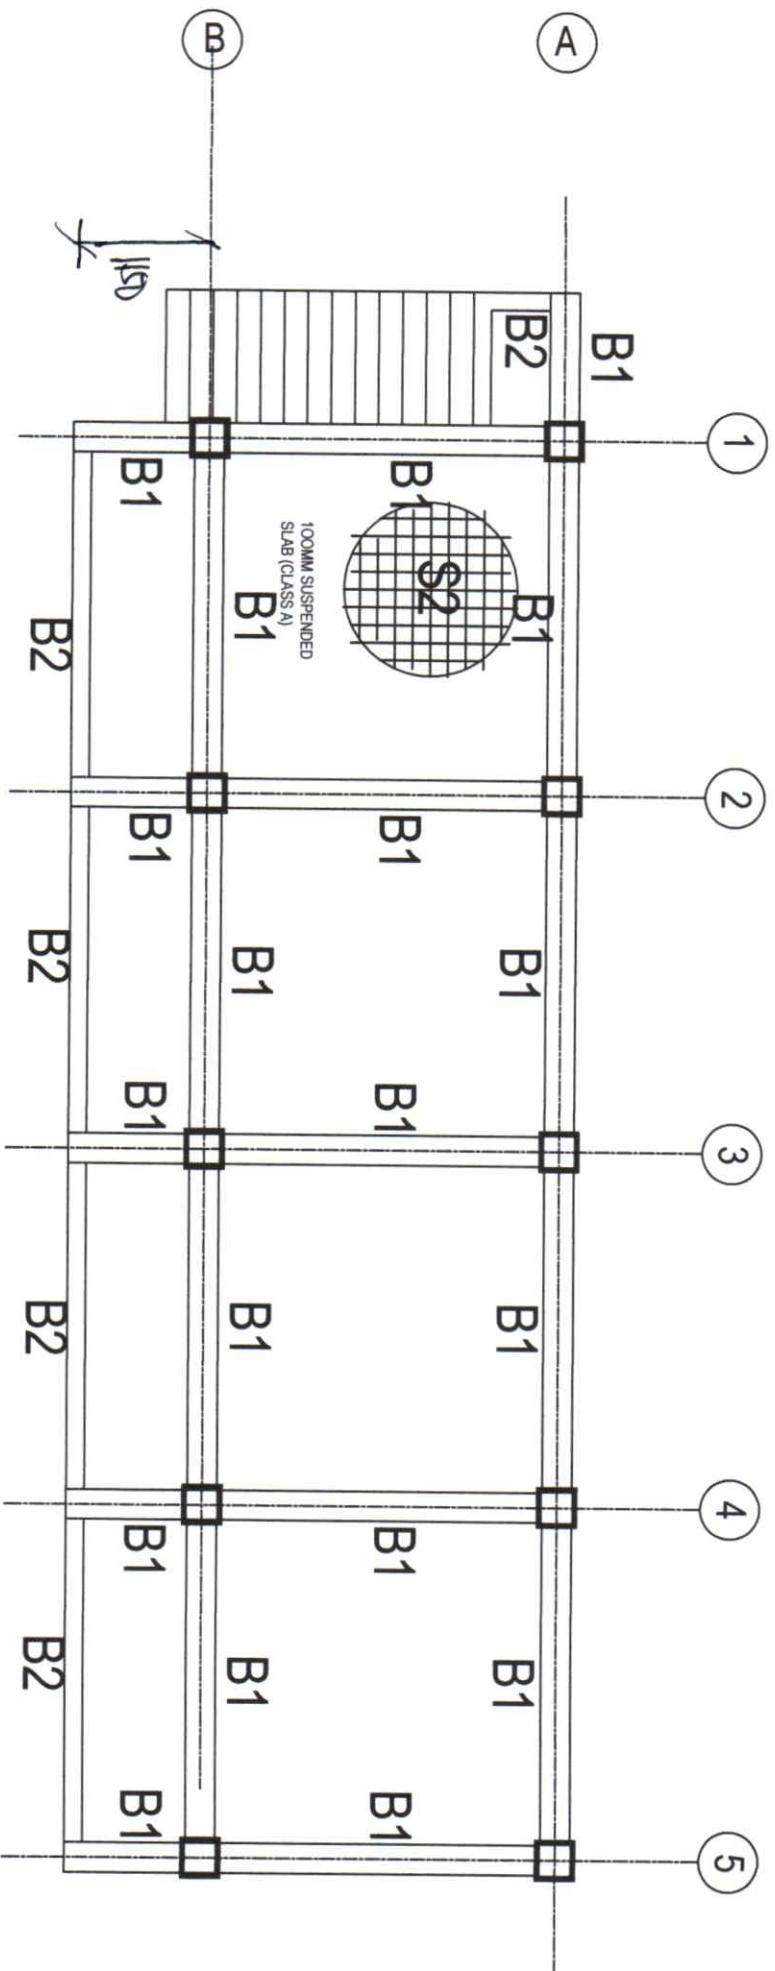

3 2ND FLR FRAMING PLAN S SCALE 1:25M

 <p>Republic of the Philippines Cordillera Administrative Region DEPARTMENT OF EDUCATION SCHOOLS DIVISION OFFICE OF BAGUIO CITY 092 MILITARY CUT-OFF, BAGUIO CITY</p>	<p>PROJECT TITLE/LOCATION</p> <p>PROPOSED CONSTRUCTION OF COMFORT ROOMS, HANDWASHING AND COOKING AREA COMFORT ROOM 1 & 2 (25SEATS WITH STORAGE) LUCBAN ELEMENTARY SCHOOL, CAMPOS, B.C.</p>	<p>PREPARED BY</p> <p>JENNIFERT ROLDO ENGINEER II</p>	<p>RECOMMENDING APPROVAL</p> <p>ARTUR TINGGIR Chief SCOD</p>	<p>APPROVED BY</p> <p>MARIE CAROLYN B. VERANO, CESO V Schools Division Superintendent</p>	<p>SHEET NO.</p> <p>12 / 18</p>
--	--	---	--	---	---------------------------------

 

PROJECT TITLE/LOCATION

PREPARED BY:

POLYMERIZATION OF MONOMER

[illegible]

PROPOSED CONSTRUCTION OF
COMFORT ROOMS, HANDWASHING AND
COOKING AREA

COMFORT ROOM 1 & 2 (12SEATS WITH STORAGE)

ILLINOIS ELEMENTARY SCHOOL CAUCUS 2006

ENGINEER III


Child, Susan

Schools: Middlebrook Elementary School

10-29-20

13



8

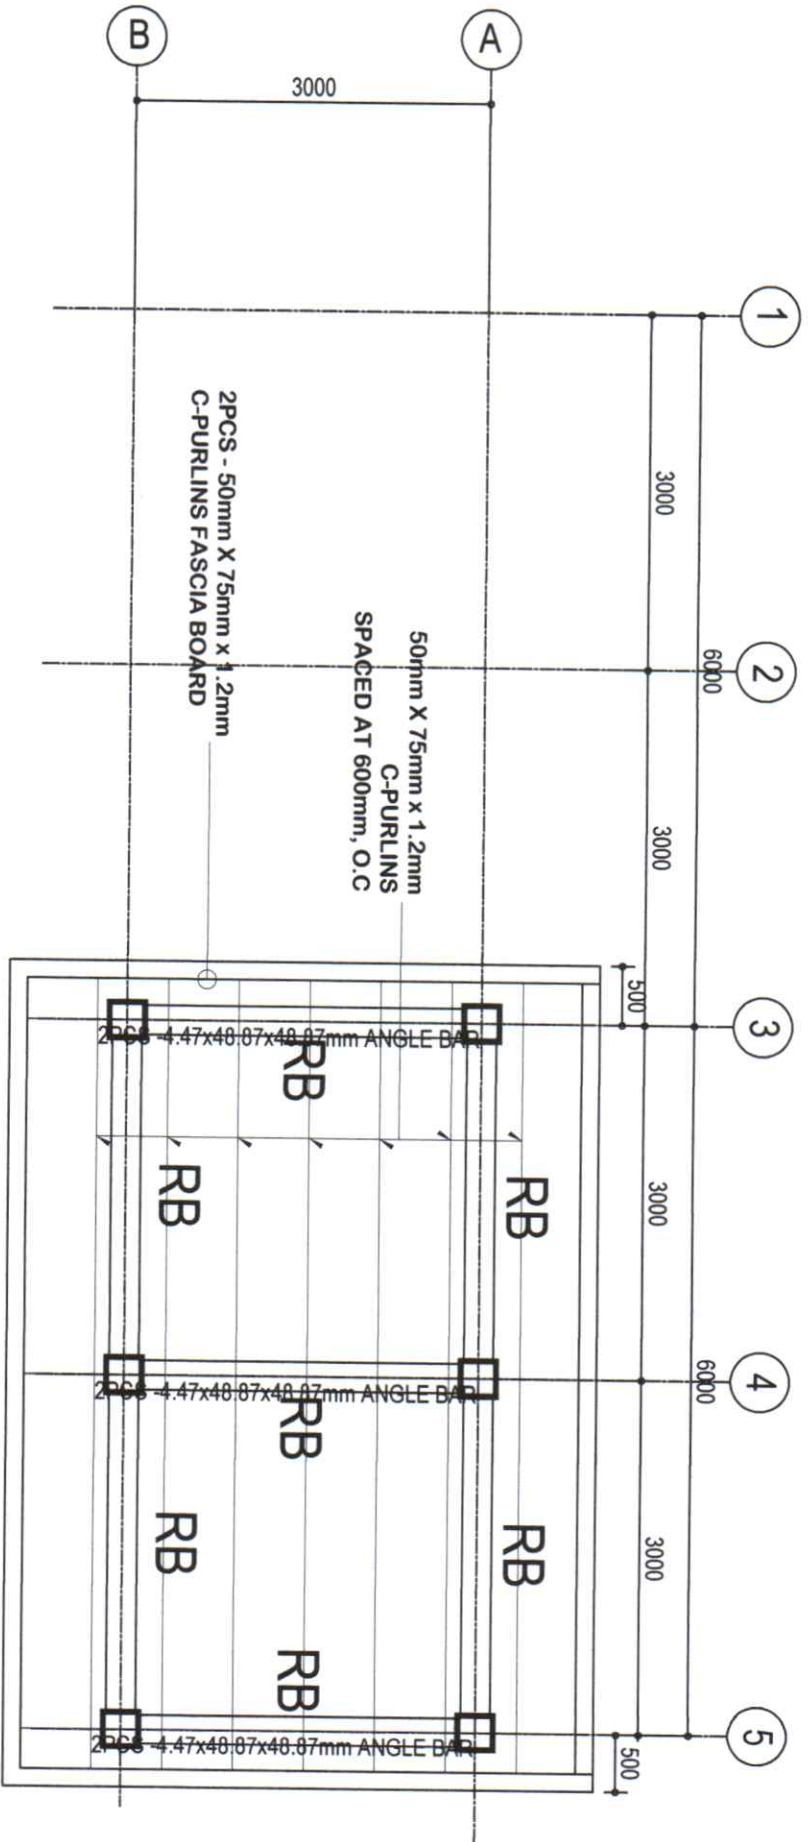



4 ROOF FRAMING PLAN

SCALE


1:25M

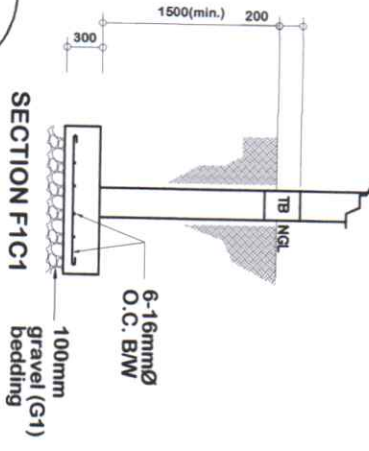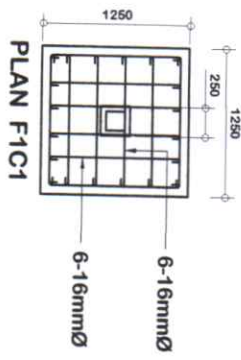

5 COLUMN FOOTING DETAIL

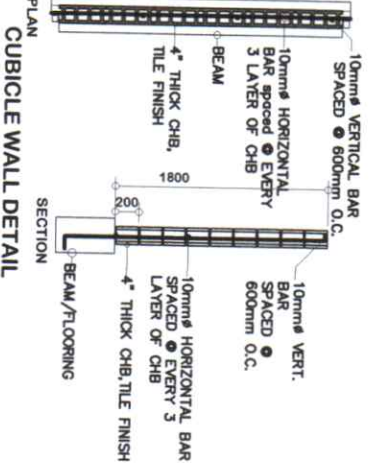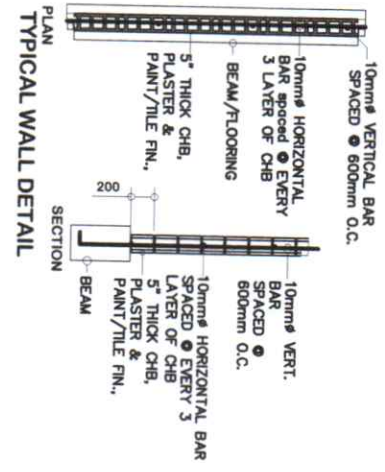

6 WALL DETAILS

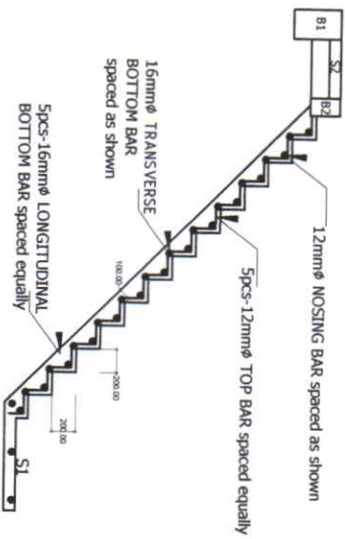

7 STAIR DETAILS



Republic of the Philippines
Cordillera Administrative Region
DEPARTMENT OF EDUCATION
SCHOOLS DIVISION OFFICE OF BAGUIO CITY
082 MILITARY CUT-OFF, BAGUIO CITY

PROJECT TITLE/LOCATION

PREPARED BY

RECOMMENDING APPROVAL

APPROVED BY

SHEET NO.

PROPOSED CONSTRUCTION OF
COMFORT ROOMS, HANDWASHING AND
COOKING AREA


COMFORT ROOM 1 & 2 (12SEATS WITH STORAGE)
LUCBAN ELEMENTARY SCHOOL, CAMRDS, B.C.

JENNIFER D. POLDO
ENGINEER III

APPROVED BY
CHIEF SCOD

MARIE CAROLYN B. VERANO, CESO V
Schools Division Superintendent

14
18

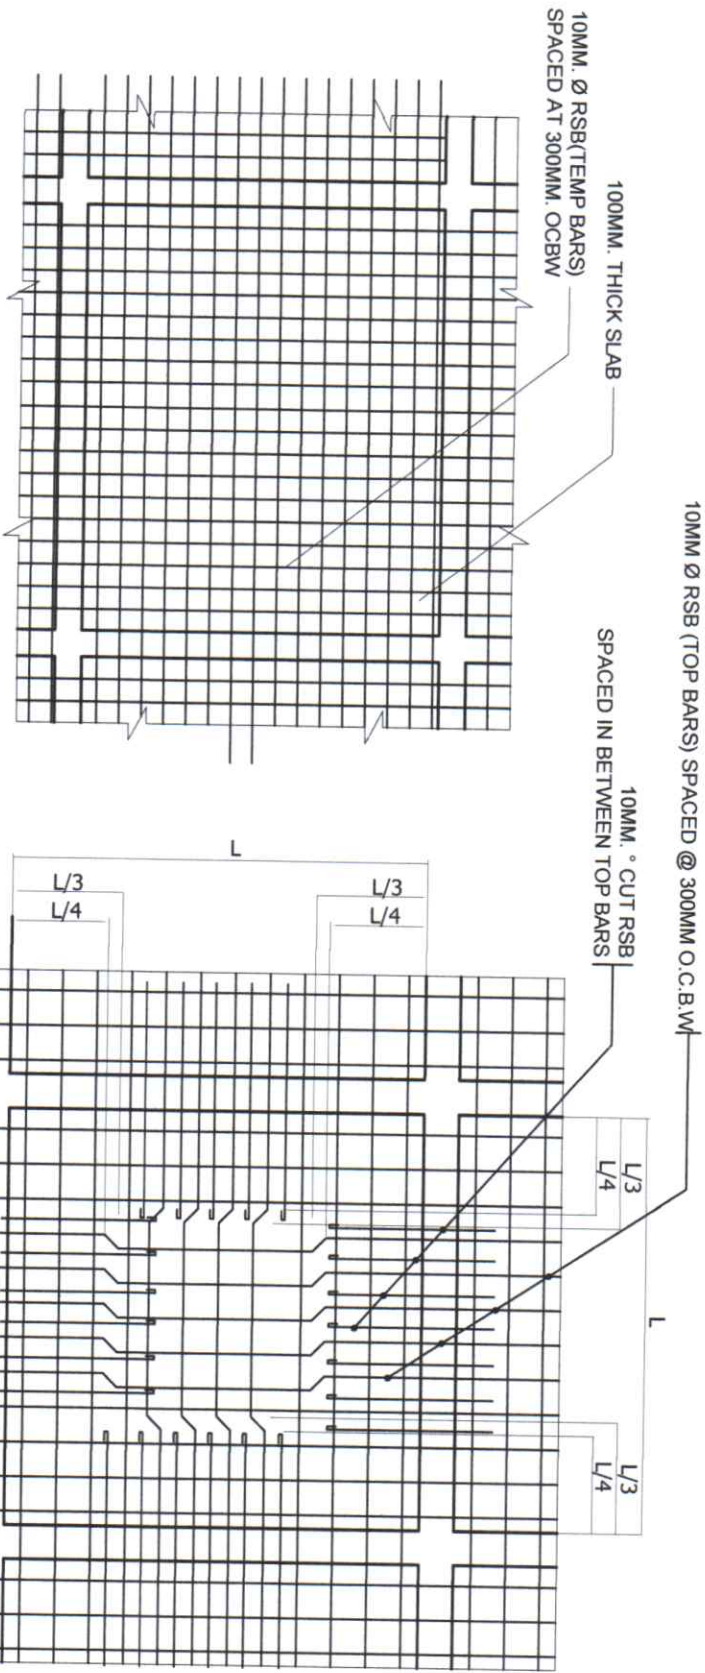

NOTE:

Minimum splice length for slab rebars must be 600mm placed alternately on opposite directions.

TEMP. BARS

8
S

S2 DETAIL CUT BARS & TOP BARS BENT AS SHOWN

SCALE

NTS



Republic of the Philippines
Cordillera Administrative Region
DEPARTMENT OF EDUCATION
SCHOOLS DIVISION OFFICE OF BAGUIO CITY
082 MILITARY CUT-OFF, BAGUIO CITY

PROJECT TITLE/LOCATION

PROPOSED CONSTRUCTION OF
COMFORT ROOMS, HANDWASHING AND
COOKING AREA
COMFORT ROOM 1 & 2 (125SEAT/18 WITH STORAGE)
LUCBAN ELEMENTARY SCHOOL, COMOG, B.C.

PREPARED BY

JENNIFER D. POLDIO
ENGINEER III

RECOMMENDING APPROVAL

ARTHUR TIANJIAN
Chief SCOO

APPROVED BY

MARIE CAROLYN B. VERANO, CESO V
Schools Division Superintendent
10-24-19


SHEET NO.

15
18

C1	TB	B1	B2	RB
TIES 10mmØ DEFORMED BARS SPACED 5@ 50mm, 5@ 75mm, 5@ 100mm and REST @ 150mm up to CENTERLINE				

9
S



COLUMN/BEAM SCHEDULE

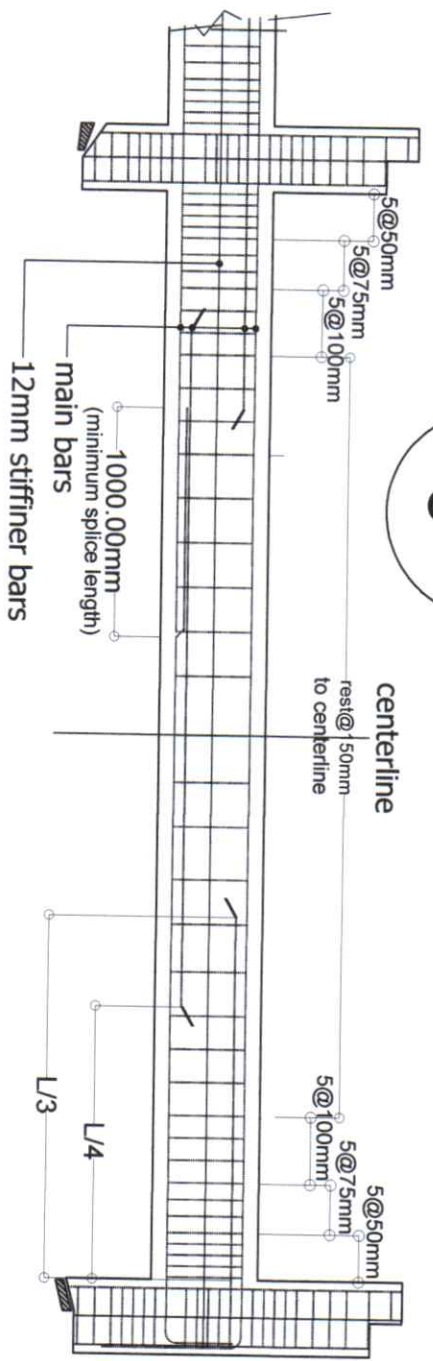

10
S

BEAM SPlicing, HOOKS & STIRRUPS

		Republic of the Philippines Cordillera Administrative Region DEPARTMENT OF EDUCATION SCHOOLS DIVISION OFFICE OF BAGUIO CITY 082 MILITARY CUT-OFF, BAGUIO CITY	
PROJECT TITLE/LOCATION PROPOSED CONSTRUCTION OF COMFORT ROOMS, HANDWASHING AND COOKING AREA COMFORT ROOM 1 & 2 (12SEATS WITH STORAGE) LUCBAN ELEMENTARY SCHOOL, CAMARAS, B.C.		PREPARED BY: JENNIFER R. SOLIDO ENGINEER III	RECOMMENDING APPROVAL: ARTHUR TUGANO Chief SDOO
		APPROVED BY: MARIE CAROLYN B. VERANO, CESO V Schools Division Superintendent	SHEET NO. 16 18

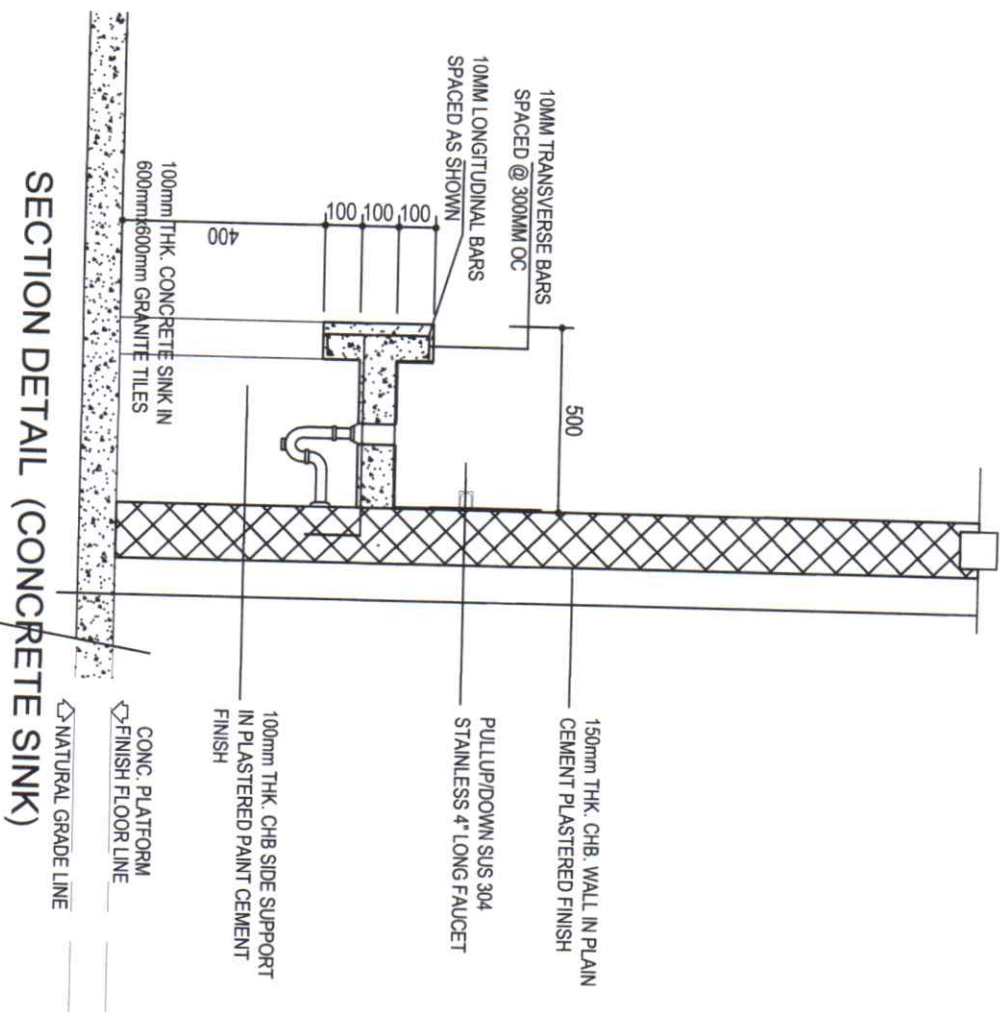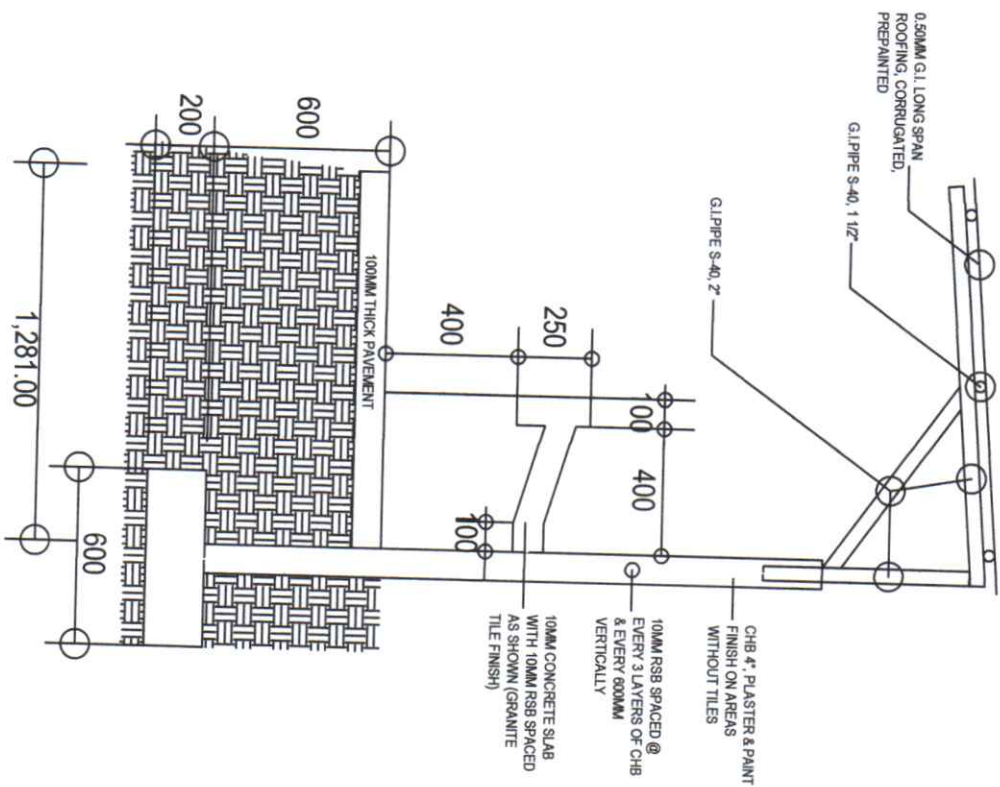

SECTION DETAIL (HANDWASHING) L=10M - 2 SETS

	<p>Republic of the Philippines Cordillera Administrative Region DEPARTMENT OF EDUCATION SCHOOLS DIVISION OFFICE OF BAGUIO CITY 082 MILITARY CUT-OFF, BAGUIO CITY</p>	<p>PROJECT TITLE/LOCATION</p>	<p>PREPARED BY</p>	<p>RECOMMENDING APPROVAL</p>	<p>APPROVED BY</p>	<p>SHEET NO.</p>
<p>PROPOSED CONSTRUCTION OF COMFORT ROOMS, HANDWASHING AND COOKING AREA HANDWASHING LUGBAN ELEMENTARY SCHOOL, CAMANG, B.C.</p>	<p>JENNIFER D. ROLDO ENGINEER III</p>	<p>ARTURO TIANJAN Chief SDOO</p>	<p>MARIE CAROLYN B. VERANO, CESO V Schools Division Superintendent 10-29-10</p>	<p>17 18</p>		



Optilux Integrated Solar Street Light 150W


- All in One Solar Street Light
- Solar Panel: 250 Watts (Monocrystalline)
- Light Source: LED SMD(Bridgelux)
- Motion Sensor: With Build-in Motion Sensor
- Lumious Flux: 15,000 lm
- Battery: Lithium Battery
- Visual Angle: 120 degrees
- Color Temperature: 2700-6500K
- IP Rating: IP65
- Lifetime: 50,000 Hours
- Working Time: 10 hours Full Power/24 hours Half Power

FOR SOLAR PERIMETER LIGHT

Optilux Integrated Industrial Solar Street Light 150W

- All in One Solar Street Light
- Solar Panel: (mono)
- Lumious Flux: 15,000 lm
- Battery: Lithium Battery
- Visual Angle: 120 degrees
- Color Temperature: 6000K-65000K
- Install Height: 7-9 meters
- Light Space: 25-30 meters
- IP Rating: IP65
- Working Time: 10 hours Full Power/24 hours Half Power

FOR SOLAR PERIMETER LIGHT

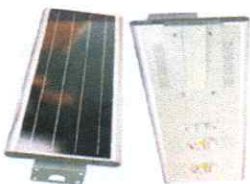

Optilux Integrated Industrial Solar Street Light 150W

- All in One Solar Street Light
- Solar Panel: (mono)
- Lumious Flux: 15,000 lm
- Battery: Lithium Battery
- Visual Angle: 120 degrees
- Color Temperature: 6000K-65000K
- Install Height: 7-9 meters
- Light Space: 25-30 meters
- IP Rating: IP65
- Working Time: 10 hours Full Power/24 hours Half Power

FOR SOLAR PERIMETER LIGHT



High Bay LED Light



- Excellent power variety: 100W, 120 W, 150 W
- Meanwell Driver - Dimmable option available
- Aluminum housing with perspex lens cover
- Compact design with excellent heat dissipation
- Suited for indoor and outdoor use - IP65 Rating
- True 140 Lumens/Watt output from fixture
- Used in conjunction with Analogue and DALI dimming systems
- Certified LM80 report on Nichia chipset and performance - no false claims!
- 45,000 hour lifespan. (65,000 hours if running below ambient temperature of 25°C)
- Variety of colour rings to easily identify power of fixture
- Optional mounting bracket to change to a floodlight fitting also available
- Coloured rings to identify power rating

FOR COVERED COURT LIGHTING

200 Watts Optilux Industrial LED High Bay Light



- Wattage: 200 Watts
- Lumens: 20000lm
- Lighting Angle: 45° ~ 90° ~ 120°
- Voltage: AC85V/265V
- Burning Hours: >50,000
- Color: Warm White, Nature White & Pure White
- Lamp Body Material: Aluminum Housing + Acrylic Lens + Reflector

FOR COVERED COURT LIGHTING



Office of the President
DEPARTMENT OF EDUCATION
SCHOOLS DIVISION OFFICE - BAGUIO CITY
0800 MALAY OUT-OF- BAGUIO CITY

PROJECT & LOCATION

PROPOSED CONSTRUCTION OF COOKING ROOMS,
COOKING AREA & HANDWASHING AT LUGBAN
ELEMENTARY SCHOOL.

ELECTRIFICATION

PREPARED BY:

JESTER BETH N. CALIXTO
Electrical Engineer

RECOMMENDING APPROVAL BY:

ARTHUR ANJUMAN
Chief, SDO

APPROVED BY:

MARIE CAROLYN A. VERANO, CESO V
Schools Division Superintendent

SHEET NO.

