

 
Republic of the Philippines
Department of Education
Cordillera Administrative Region
SCHOOLS DIVISION OF BAGUIO CITY
QUEZON HILL NATIONAL HIGH SCHOOL
LAMUG ST., MIDDLE QUEZON HILL, BAGUIO CITY

REQUEST FOR QUOTATION

Company/Supplier/Store: _____
Address: _____
Telephone No.: _____
e-Mail: _____
TIN: _____

PR No.: **2026-08-043**
Quotation No.: **2026-08-040**
Date: August 25, 2026
ABC: **Php 400, 000.00**

Please quote your lowest price on the item/s listed, subject to the General Conditions below, stating the shortest time of delivery and **submit your quotation in a sealed envelope** duly signed by your representative not later than **September 02, 2026 @9:00 A.M.**


FRAMYR B. YMANA

Chairperson, Bids and Awards Committee

REQUIREMENTS:

1. Mayor's / Business permit
2. PhilGEPS registration number or certificate
3. PCAB License
4. Omnibus Sworn Statement (for ABC above 50K)
5. Income/Business Tax Return (for ABC above 500K)

Note:

- ✓ Submit RFQ together with the requirements.
- ✓ All entries must be typewritten or legibly written.
- ✓ Delivery period within **30** Calendar Days.
- ✓ Price validity shall be for a period of **30** Calendar Days.

Item No.	Qty.	Unit	Item Description	Unit Price	Total Price
			Lot		
B.9	1.00	lumpsum	Mobilization/Demobilization		
801(1)	1.00	lumpsum	Removal of Structures and Obstructions (including hauling out of waste materials)		
1046(2)a1	9.83	square meter	CHB nonload Bearing (Including Reinforcing Steel), 100 mm thick		
1027 (1)	21.63	square meter	Cement Plaster Finish		
1008(2)	5.00	square meter	Aluminum Glass Windows (sliding type & Fixed Type)		
1010(2)b.	7.35	square meter	Doors (Wood Panel)		
1003.g2.	17.97	square meter	Ceiling (PVC Metal Frame)		
1032(1)a1.	46.58	square meter	Painting Works-Exterior Walls, Beams, Columns		
1032(1)a2.	84.00	square meter	Painting Works-Interior Walls, Beams, Columns		
1001(11)	1.00	lumpsum	Septic Vault (Concrete/CHB)		



Address: Lamug St., Middle Quezon Hill, Baguio City
Email address: quezonhillnhs@gmail.com; 305287@deped.gov.ph
Telephone Number: (074) 619-6723



Republic of the Philippines
Department of Education
Cordillera Administrative Region
SCHOOLS DIVISION OF BAGUIO CITY
QUEZON HILL NATIONAL HIGH SCHOOL
LAMUG ST., MIDDLE QUEZON HILL, BAGUIO CITY

1002(5)b	4.00	set	Water Closet, Elongated, Complete (Flush type)		
1002(9)a	2.00	set	Urinal, Flush Valve, Complete, Push Button Type		
1002(12)	3.00	set	Scrub up sink, Complete		
1002(16)a3	6.00	set	Floor Drain Plates, 100 mm diam. Stainless		
1002(20)	1.02	square meter	Facial Mirror		
1002(27)	1.00	lumpsum	Plumbing Works, pipes and Fittings		
1018(5)	102.56	square meter	Glazed Tiles		
SPL.1	1.00	lumpsum	Electrical Works		
1200(5) b.	5.00	sets	Exhaust fan, Wall mounted		
SPL 1	38.00	square meter	Roofing System		
			See attached Bill of Quantities and Detailed Blank Estimates		

PURPOSE: Procurement of Construction Services for the renovation of male comfort room

After having carefully read and accepted your General Conditions, I/We quote you on the item at prices noted above.

Canvassed by

Signature over Printed Name

Tin

Contact number



Address: Lamug St., Middle Quezon Hill, Baguio City
Email address: quezonhillnhs@gmail.com; 305287@deped.gov.ph
Telephone Number: (074) 619-6723



Republic of the Philippines
Department of Education
CORDILLERA ADMINISTRATIVE REGION
SCHOOLS DIVISION OFFICE OF BAGUIO CITY
QUEZON HILL NATIONAL HIGH SCHOOL



ITEM NO.	DESCRIPTION	LABOR COST	RENTALS	MATERIAL COST	TOTAL DIRECT COST	VAT	TOTAL COST
B.9	Mobilization/Demobilization						
801(1)	Removal of Structures and Obstructions (including hauling out of waste materials)						
1046(2)a1	CHB nonload Bearing (Including Reinforcing Steel),100 mm thick						
1027 (1)	Cement Plaster Finish						
1008(2)	Aluminum Glass Windows (sliding type & Fixed Type)						
1010(2)b	Doors (Wood Panel)						
1003.g2	Ceiling (PVC Metal Frame)						
1032(1)a1	Painting Works-Exterior Walls, Beams, Columns						
1032(1)a2	Painting Works-Interior Walls, Beams, Columns						
1001(11)	Septic Vault (Concrete/CHB)						
1002(5)b	Water Closet Elongated, Complete (Flush type)						
1002(9)a	Urinal, Flush Valve, Complete, Push Button Type						
1002(12)	Scrub up sink, Complete						
1002(16)a3	Floor Drain Plates, 100 mm diam. Stainless						
1002(20)	Facial Mirror						
1002(27)	Plumbing Works , pipes and Fittings						
1018(5)	Glazed Tiles						
SPL 1	Electrical Works						
1200(5) b	Exhaust fan, Wall mounted						
SPL 1	Roofing System						
TOTAL CONSTRUCTION COST							

- A. Total Material Cost
B. Total Labor Cost
C. Total Equipment Rentals
D. Hauling Cost
E. TOTAL DIRECT COST.....

Plus:


- F. MARK-UPS
OCM and Contractors Profit
G. BIR
VAT (10 % of Total Labor and Equipment)
H. TOTAL INDIRECT COST

Add:


- I. OVERHEAD EXPENSES
Engineering & Admin. Overhead
J. 1% Quality Control

K. TOTAL PROJECT COST

PREPARED BY:

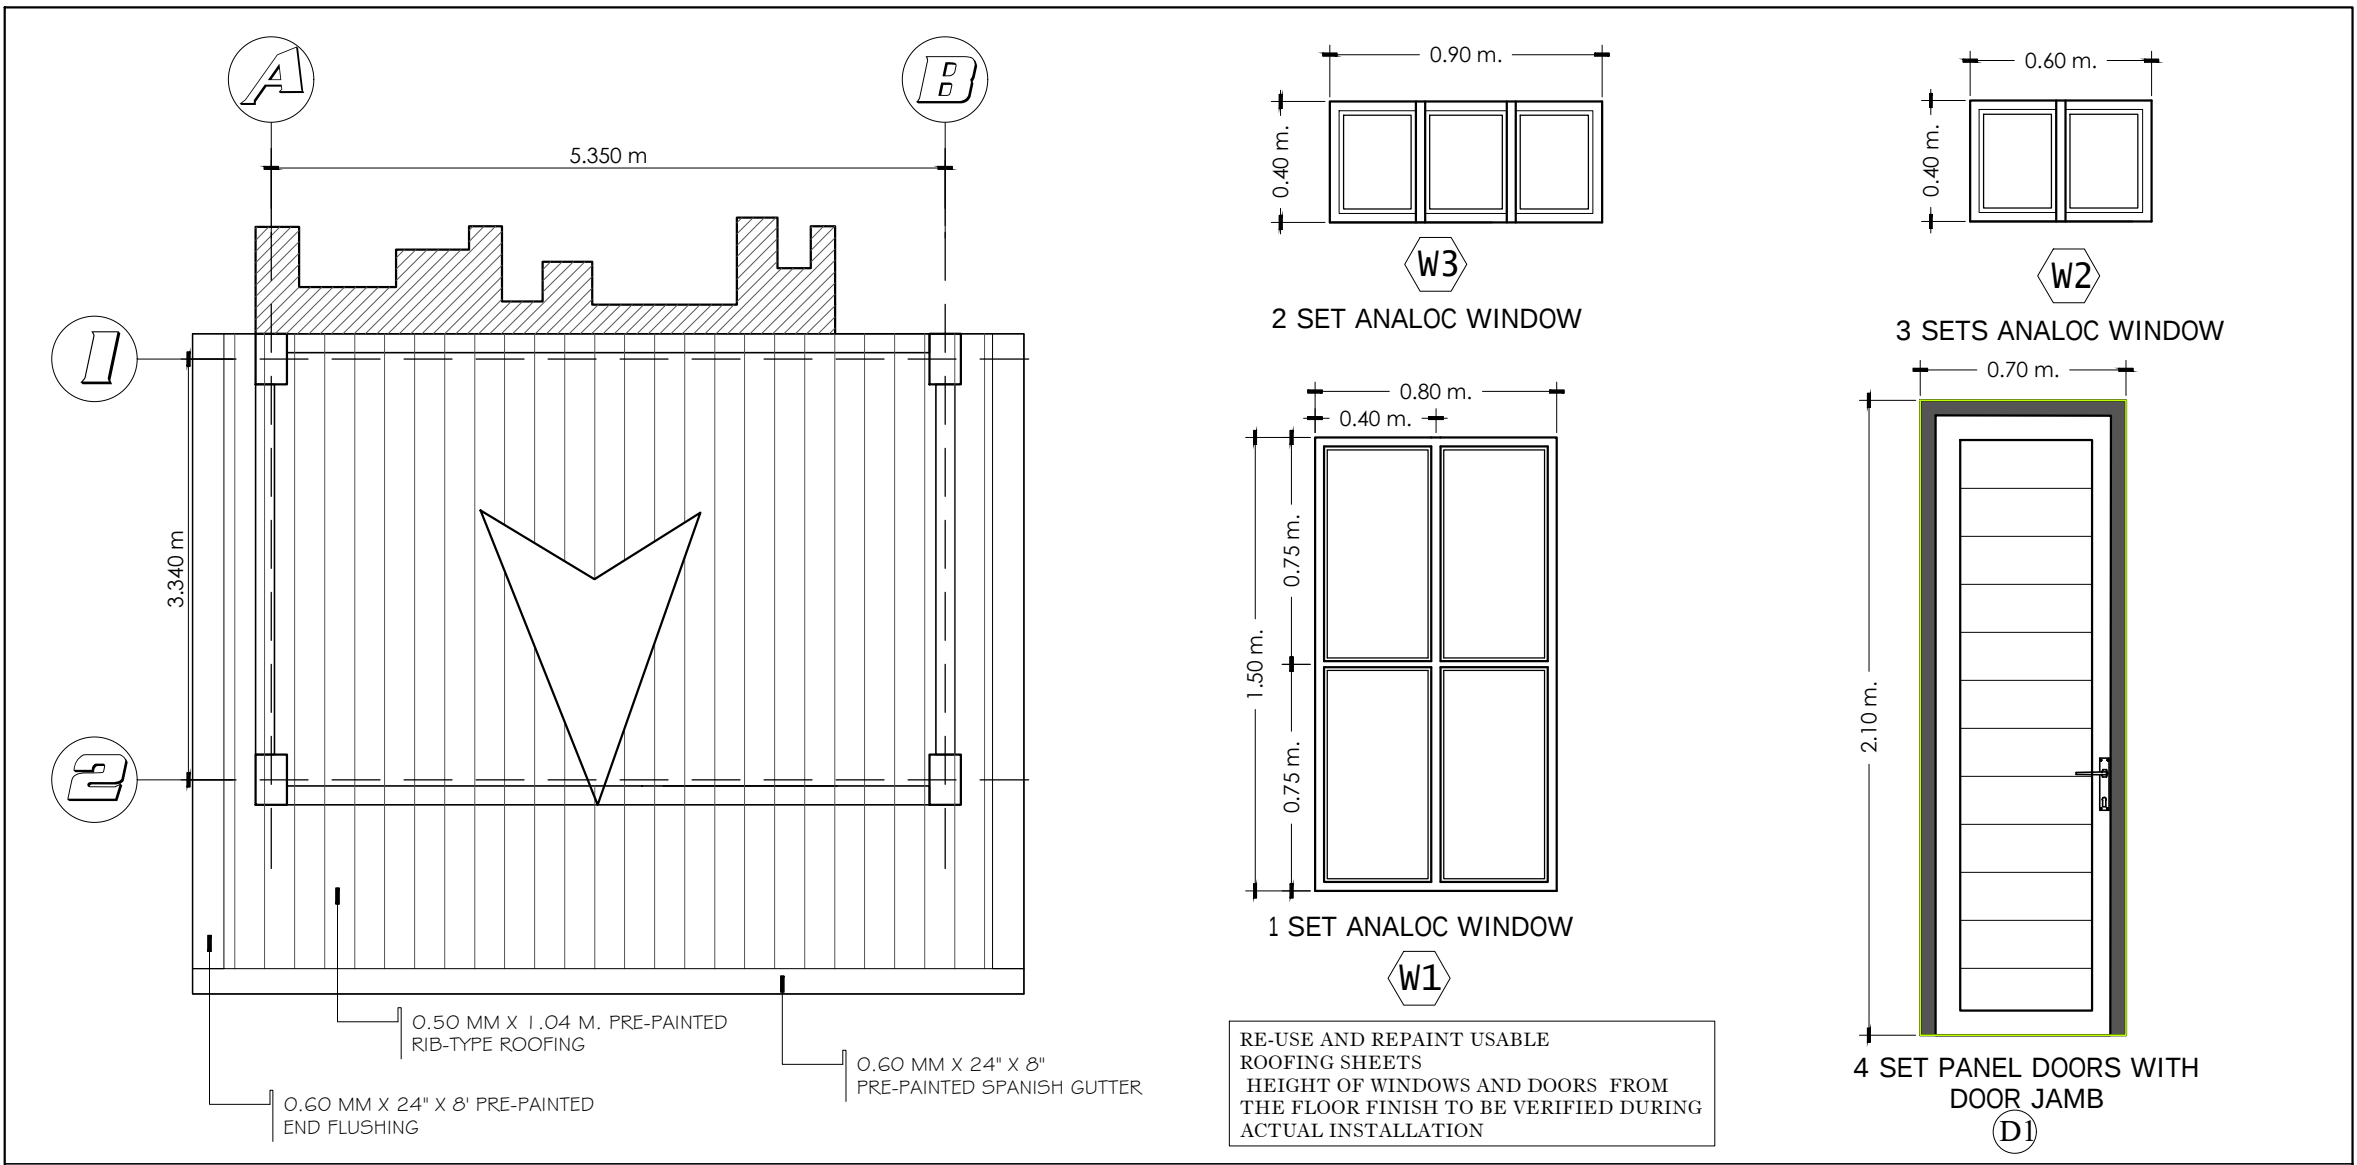

1 ROOFING SYSTEM				2 DOORS AND WINDOWS SCHEDULE				
3 3		SCALE		3 3		SCALE		
		1:60				1:25		
	 SCHOOLS DIVISION OFFICE #82 MILITARY CUTOFF RD, BAGUIO CITY	PROJECT TITLE & LOCATION:	PREPARED BY:	CHECKED AND VERIFIED BY:	RECOMMENDING APPROVAL:	APPROVED:	SHEET CONTENTS:	SHEET NO:
		REPAIR OF COMFORT ROOMS AT QUEZON HILL NATIONAL HIGHSCHOOL	GERALD S. MENZI ENGINEER II	JORDAN B. GAS - IB ENGINEER III	NIÑO M. TIBANGAY CHIEF, SGOD	SORAYA T. FACULO PhD, CESO V SCHOOLS DIVISION SUPERINTENDENT		
		LOCATION	DATE:	DATE:	DATE:	DATE:		

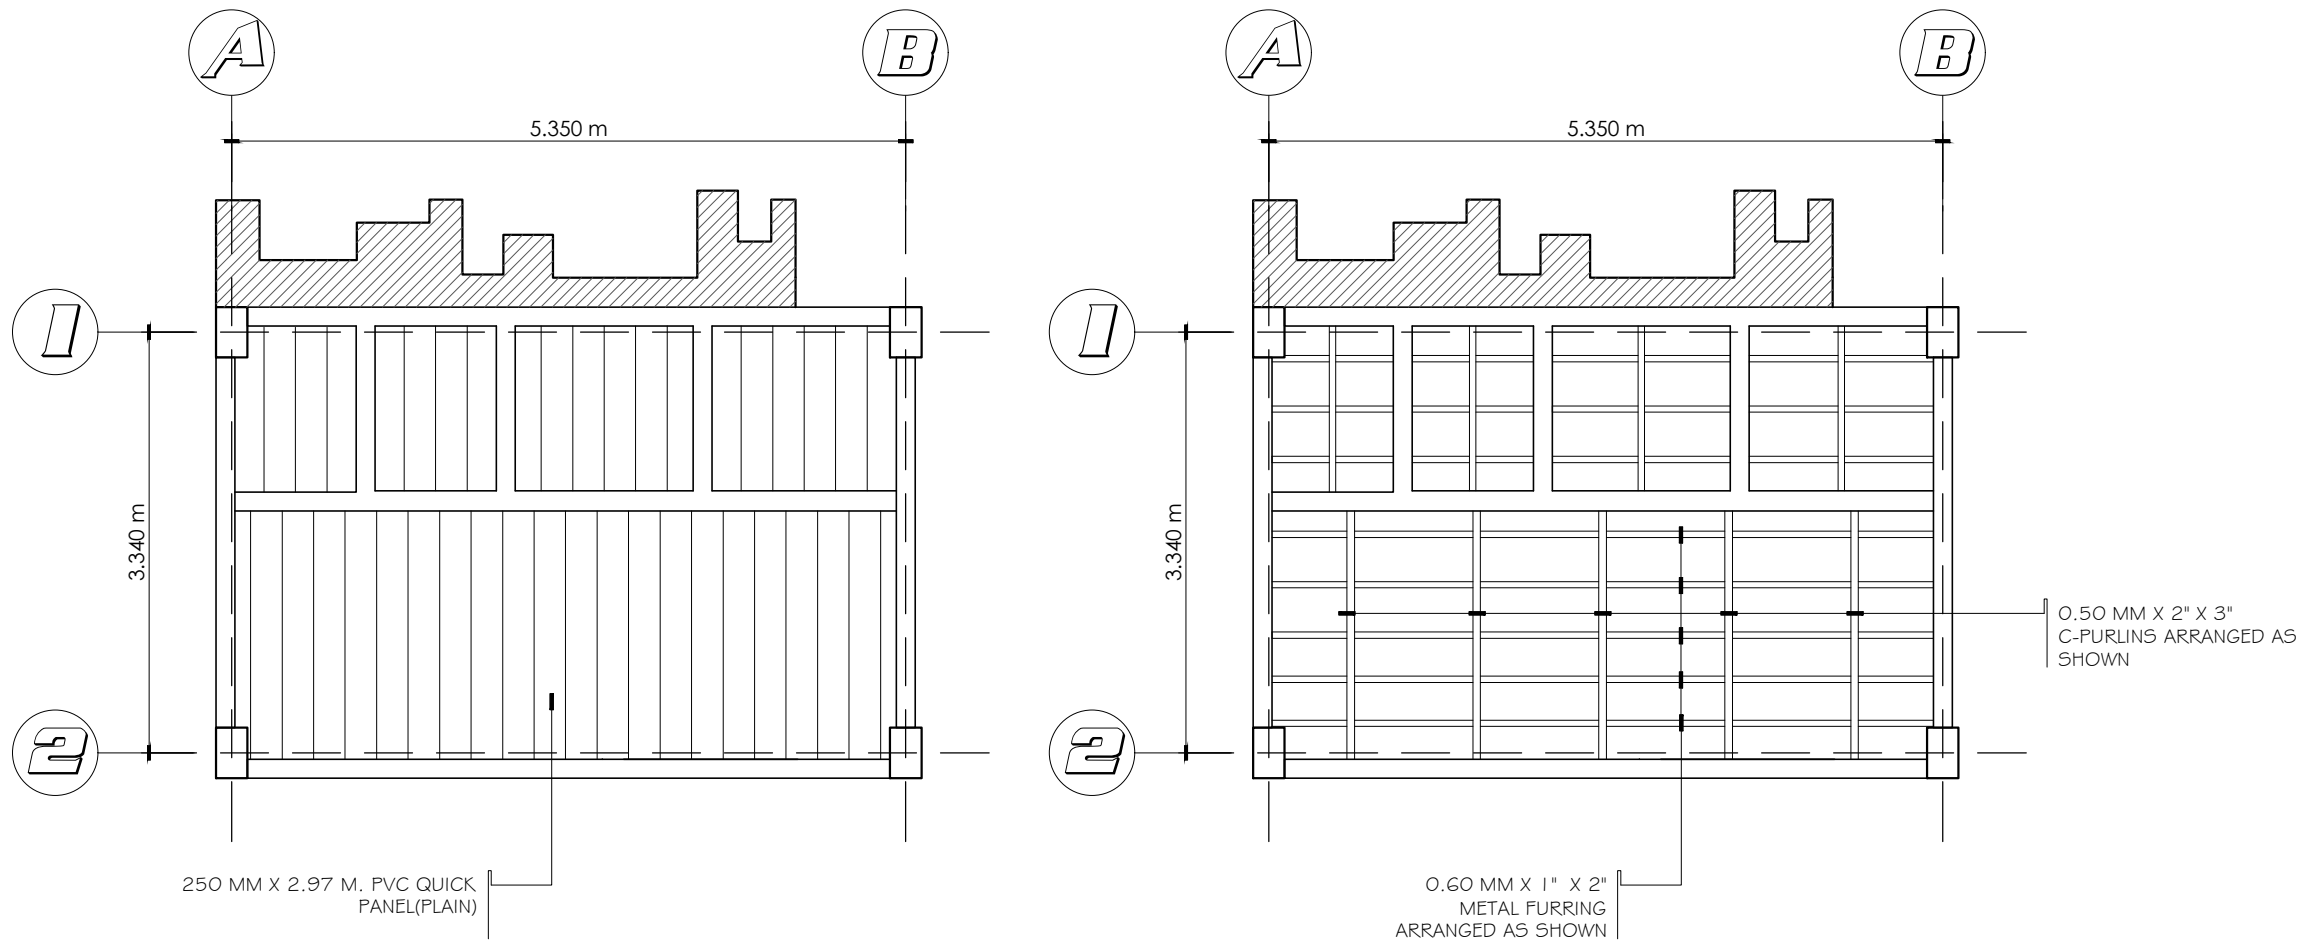

1 **COMFORT ROOMS CEILING DETAIL**


2 **2** SCALE 1:60

	 SCHOOLS DIVISION OFFICE #82 MILITARY CUTOFF RD, BAGUIO CITY	PROJECT TITLE & LOCATION: REPAIR OF COMFORT ROOMS AT QUEZON HILL NATIONAL HIGH SCHOOL LOCATION	PREPARED BY: GERALD S. MENZI ENGINEER II DATE:	CHECKED AND VERIFIED BY: JORDAN B. GAS - IB ENGINEER III DATE:	RECOMMENDING APPROVAL: NIÑO M. TIBANGAY CHIEF, SGOD DATE:	APPROVED: SORAYA T. FACULO PhD, CESO V SCHOOLS DIVISION SUPERINTENDENT DATE:	SHEET CONTENTS:	SHEET NO:
--	---	---	--	--	---	--	-----------------	-----------

PROJECT TITLE: REPAIR OF COMFORT ROOMS AT QUEZON HILL NATIONAL HIGHSCHOOL
APPROPRIATIONS: 400,000.00
APPROVED BUDGET OF CONTRACT: 461,000.00
SOURCE OF FUND: QUICK RESPONSE FUND
PROJECT DURATION: 35 DAYS

GENERAL NOTES

- 1. REMOVAL OF EXISTING STRUCTURES
- 2. REPLACEMENT OF CEILING MATERIALS (INCLUDING CEILING FRAMES)
- 3. REMOVE AND REPLACE EXISTING DOORS AND WINDOWS
- 4. INSTALLATION OF NEW PLUMBING FIXTURES (WATER CLOSET, URINALS AND LAVATORY AND FLOOR DRAINS)
- 5. REPLACEMENT OF DEFECTIVE ROOFING MATERIALS (ROOFING SHEETS)
- 6. EXISTING FLOORING TO BE REPLACED WITH TILES
- 7. MASONRY WORKS (INTERIOR WALLS INCLUDING WALL PLASTERING)
- 8. REPAINTING OF EXISTING WALLS (INTERIOR AND EXTERIOR)
- 9. ELECTRICAL WORKS INCLUDING THE INSTALLATION OF FAN
- 10. INSTALLATION OF FACIAL MIRROR

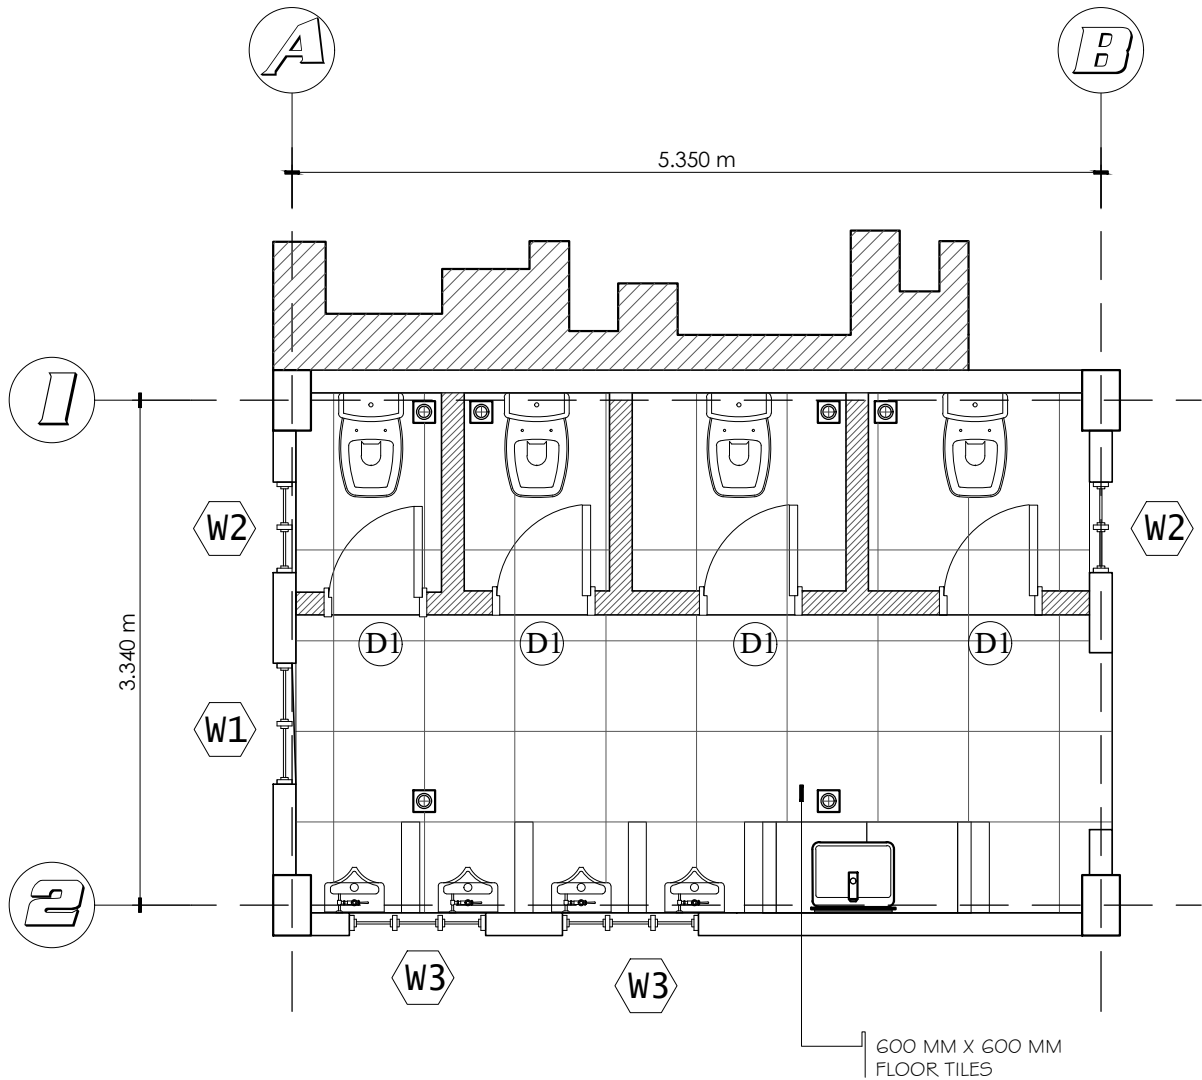

1 COMFORT ROOMS FLOOR PLAN
1 1 SCALE 1:50

	 SCHOOLS DIVISION OFFICE #82 MILITARY CUTOFF RD, BAGUIO CITY	PROJECT TITLE & LOCATION:	PREPARED BY:	CHECKED AND VERIFIED BY:	RECOMMENDING APPROVAL:	APPROVED:	SHEET CONTENTS:	SHEET NO:
		REPAIR OF COMFORT ROOMS AT QUEZON HILL NATIONAL HIGHSCHOOL	GERALD S. MENZI ENGINEER II	JORDAN B. GAS - IB ENGINEER III	NIÑO M. TIBANGAY CHIEF, SGOD	SORAYA T. FACULO PhD, CESO V SCHOOLS DIVISION SUPERINTENDENT	- LOCATION MAP	1 3
		LOCATION	DATE:	DATE:	DATE:	DATE:		